


225 226
245 246

226 227
246 247

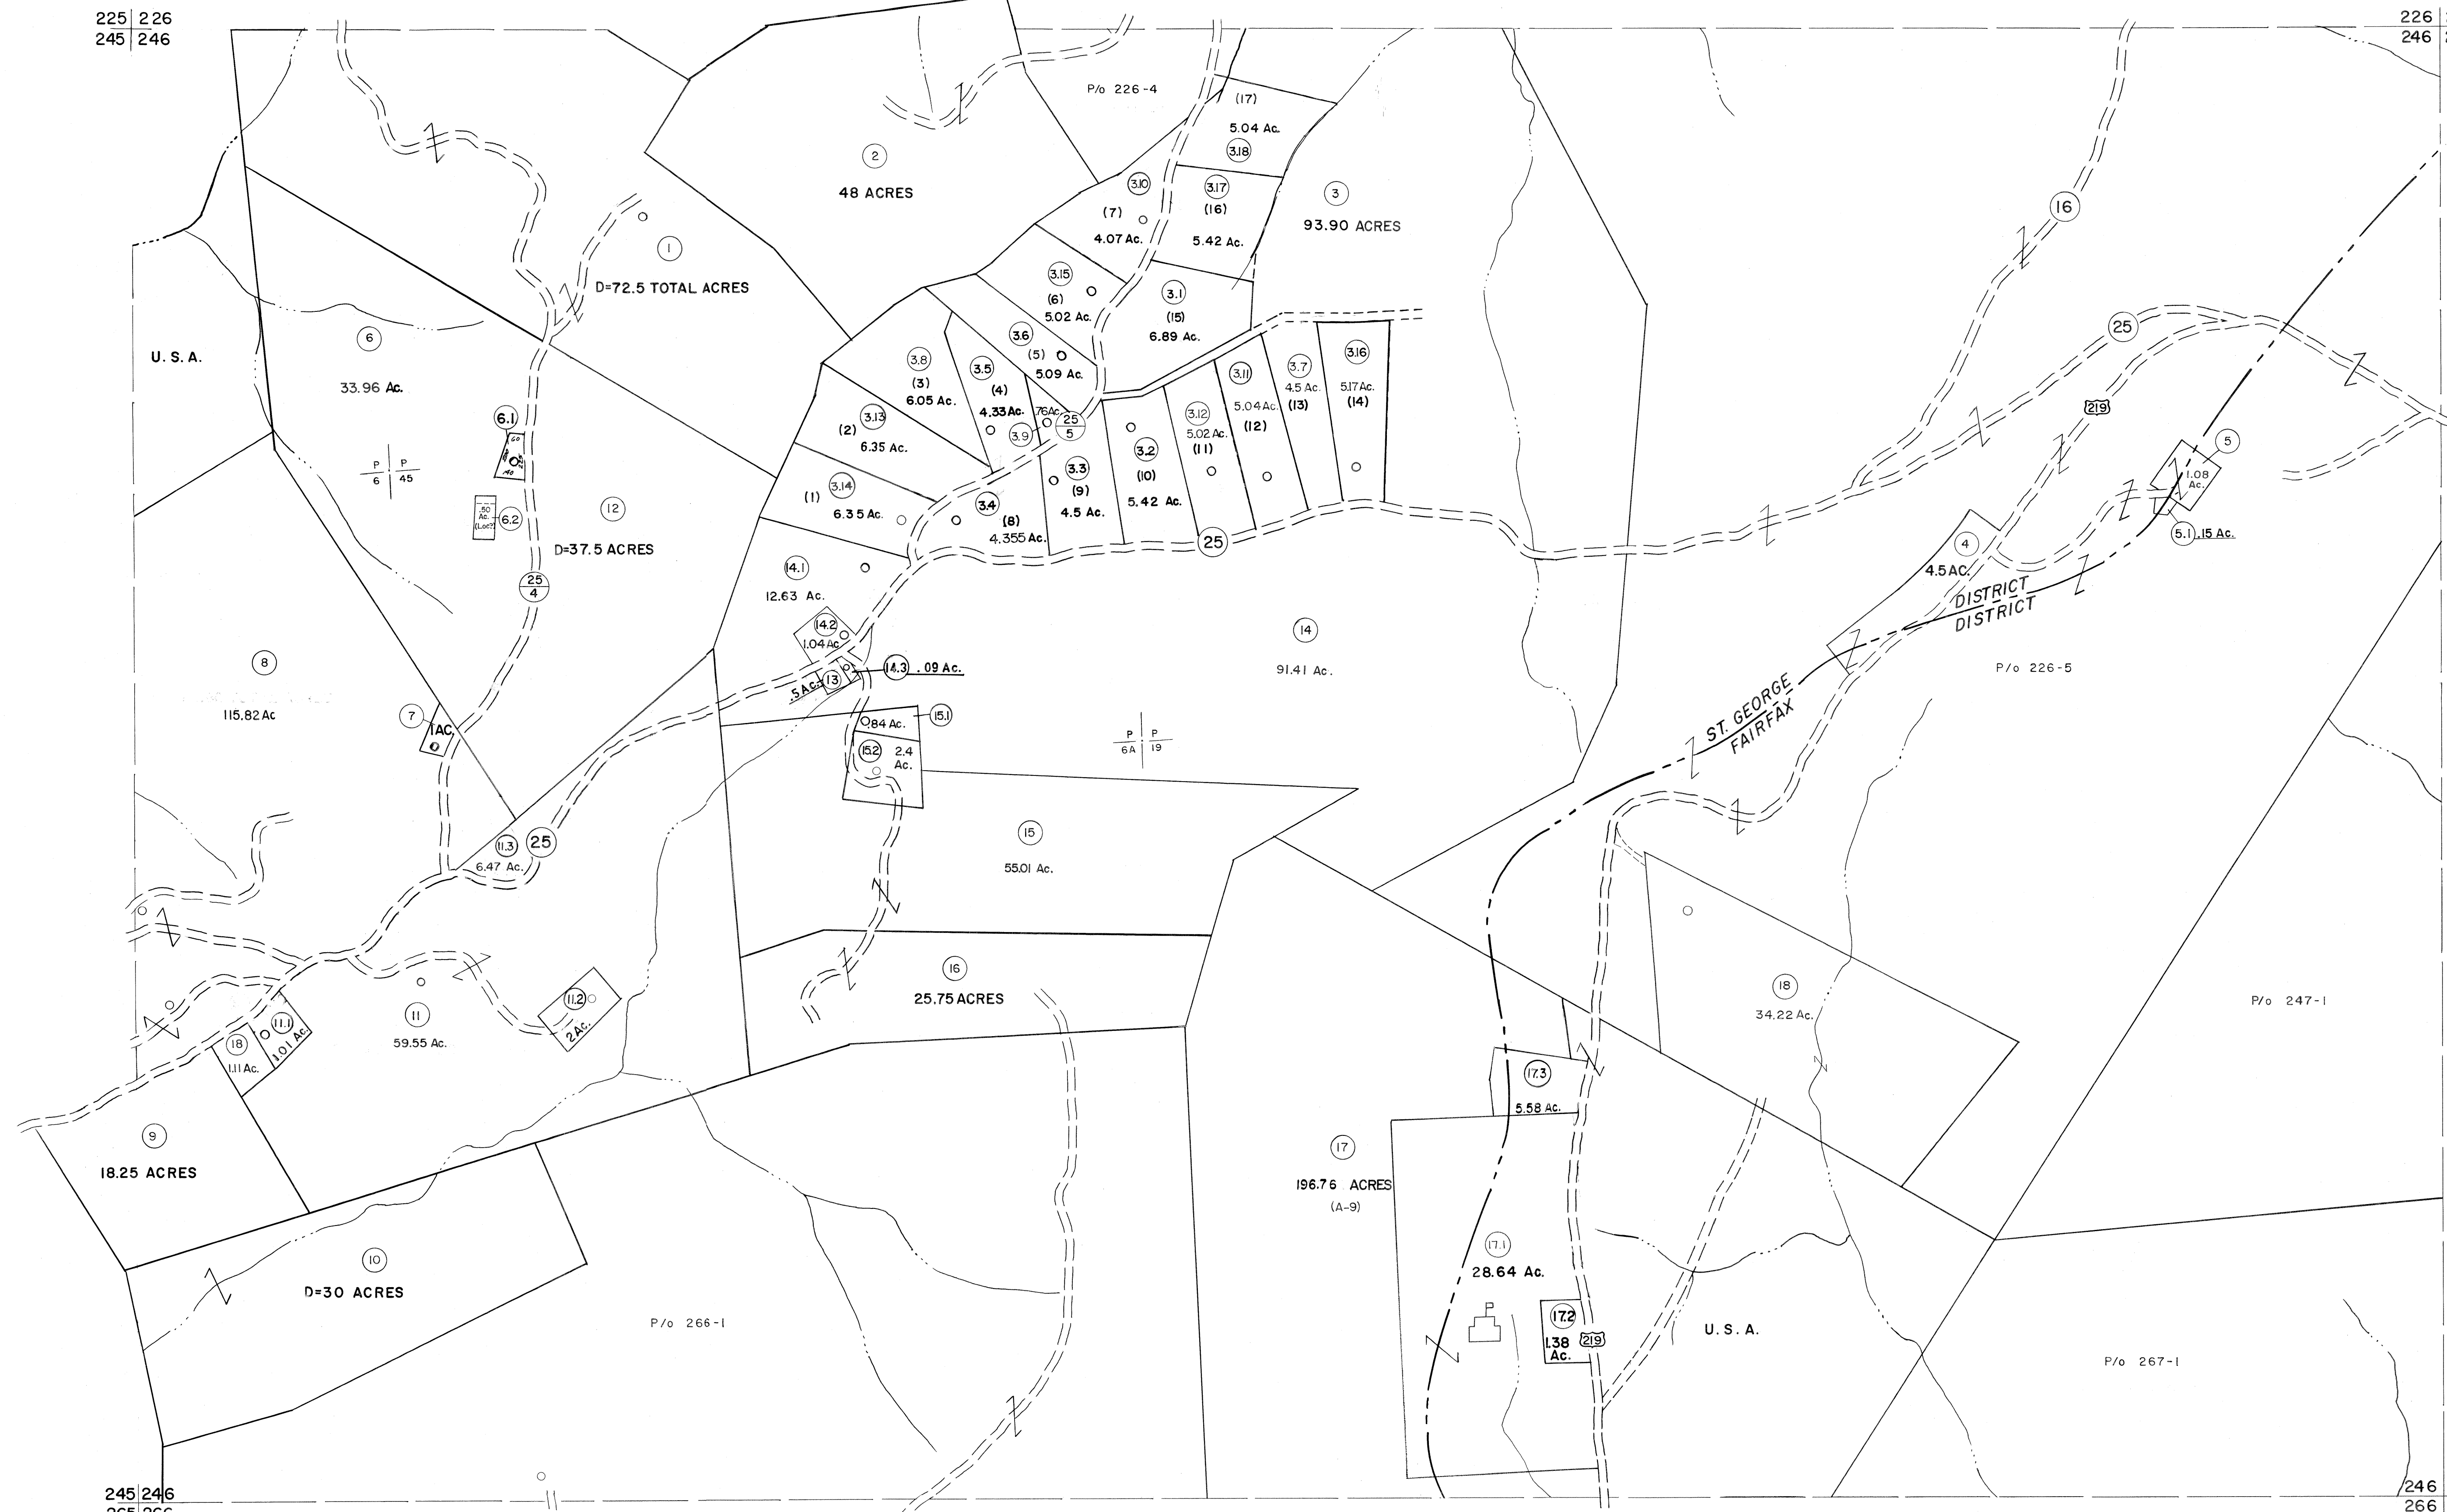


245 246
265 266

246 247
266 267

For Tax Purposes Only
 Prepared by
MICHAEL BAKER, JR., INC.
 Consulting Engineers
 Rochester, Pennsylvania

Legend	
Property line	—
Edge of pavement or roadway	—
Corporation line	—
District line	—
County line	—
Original lot line	- - - - -
Dead lot number	(15)
Parcel or index number	(25)
Improvement	o
Railroad	—+—+—+—

Revisions	
1	11-21-78 T.G.
2	Revised to 7-1-83
3	7-1-84 L.E.S.
4	REV. TO 7-1-86 NCS
5	Revised to 7-1-87
6	REV. TO 3-1-89 R.E.B.
7	OGIS 3-19-92 TL
8	OGIS 12/11/93 SAJ
9	OGIS 2-95 HD
10	O.G.I.S 4-1-96 J.E.B
11	SLS INC. - DDC 5/97
12	SLS INC. 2/23/98 JWM
13	ESI 2/8/02 REK
14	OGIS 3-19-92 TL
15	OGIS 12/11/93 SAJ
16	OGIS 2-95 HD
17	ESI 2/20/03 REK
18	HAS 2/19/03
19	3/21/05 S&H
20	3/24/07 S&H
21	
22	
23	
24	

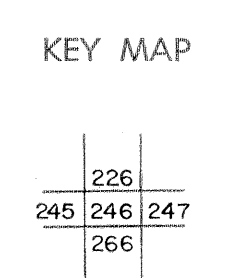

TUCKER COUNTY
 STATE OF WEST VIRGINIA
 Office of Assessor

DISTRICT **ST. GEORGE FAIRFAX**
SHEET NO: 246
 Date, Aerial Photography: Nov., 1961 Date, Map: Dec., 1962
 Photo No: Scale: 1" = 400'