


322 323  
342 343

323 324  
343 344

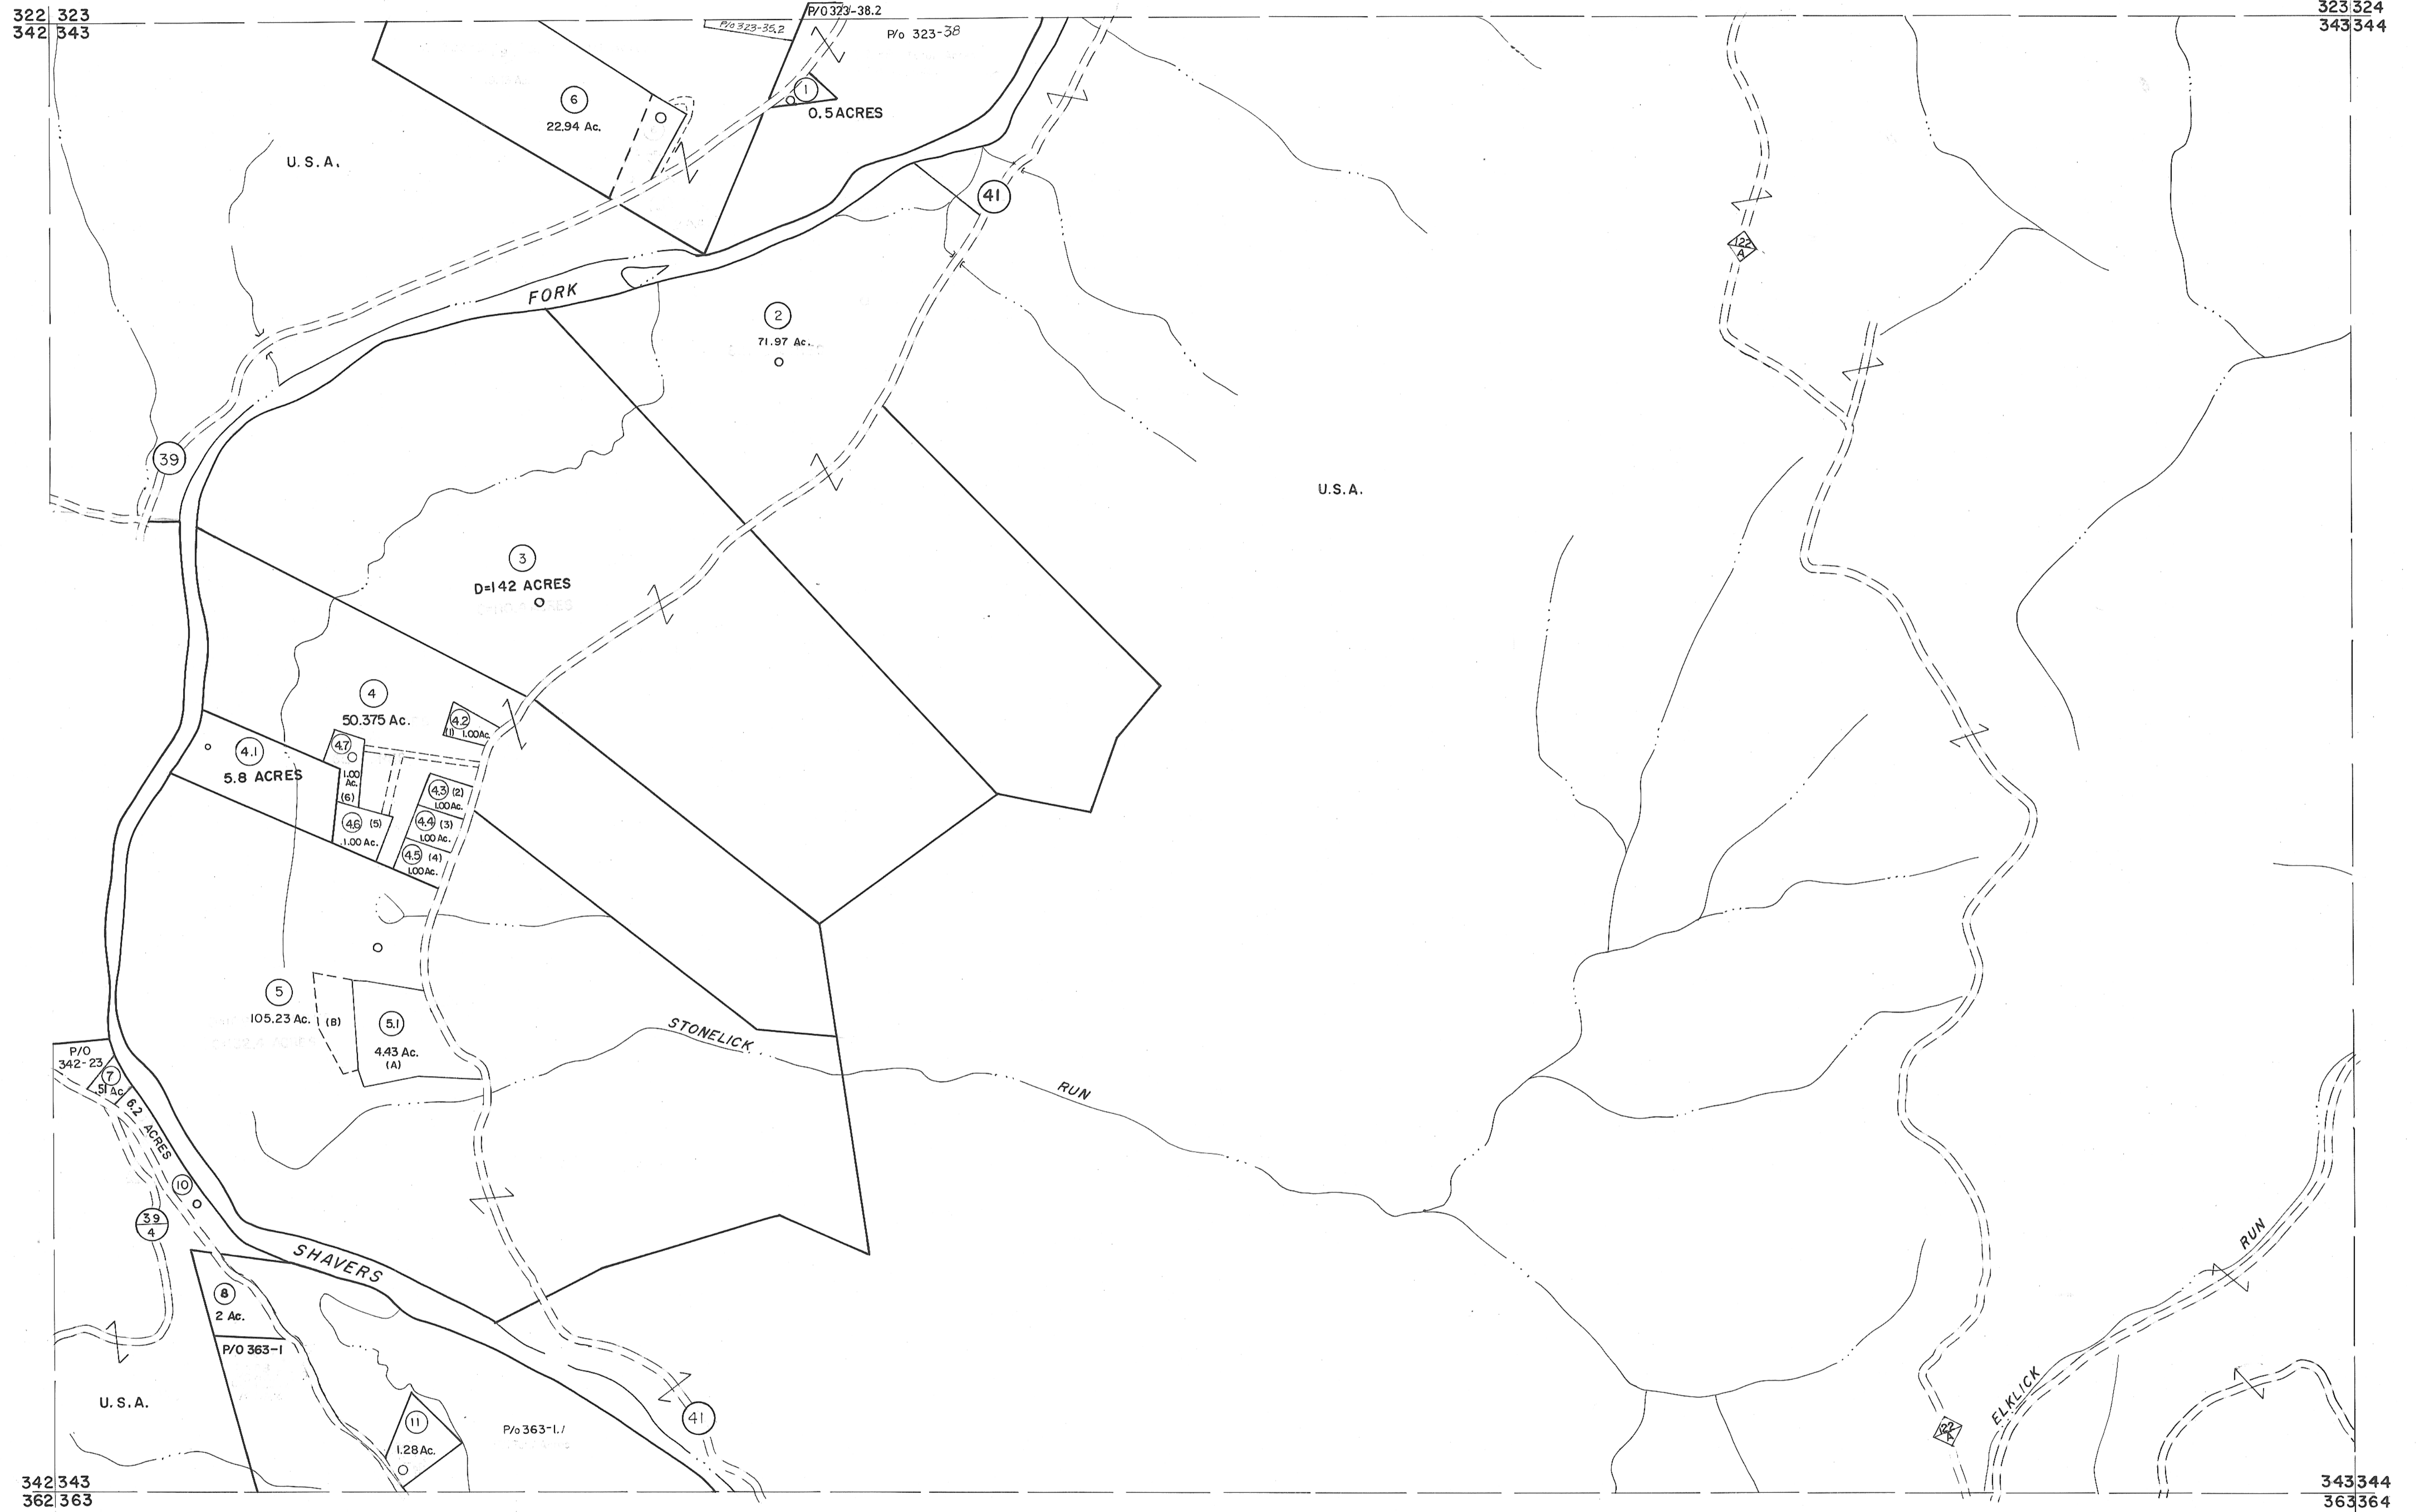

342 343  
362 363

343 344  
363 364

For Tax Purposes Only

Prepared by  
MICHAEL BAKER, JR., INC.  
Consulting Engineers  
Rochester, Pennsylvania


Legend

Property line	—	Original lot line	- - - - -
Edge of pavement or roadway	— — — — —	Deed lot number	(13)
Corporation line	— · — · — · —	Parcel or index number	(2)
District line	- - - - -	Improvement	o
County line	- - - - -	Railroad	— + — + — + —

Revisions

1	11-78	BA:11	9	ESI	2/12/02	REK	17
2	Revised to 7-1-85	J.F.	10	ESI	2/20/03	REK	18
3	July 1985	J.F.	11		6/24/11	SBH	19
4	Revised to 7-1-87	J.F.	12		5-4-13	H.S.	20
5	OGIS	1/5/91	DSH	13			21
6	OGIS	3-19-92	TL	14			22
7	O.G.I.S.	4-1-96	J.E.B.	15			23
8	SLS INC.	- DDC 5/97		16			24

KEY MAP

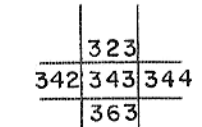

TUCKER COUNTY  
STATE OF WEST VIRGINIA  
Office of Assessor

DISTRICT  
BLACKFORK

SHEET NO: 343

Date, Aerial Photography: November, 1961 Date, Map: Dec., 1962  
Photo No: Scale: 1" = 400'