


264 265
284 285

265 266
285 286

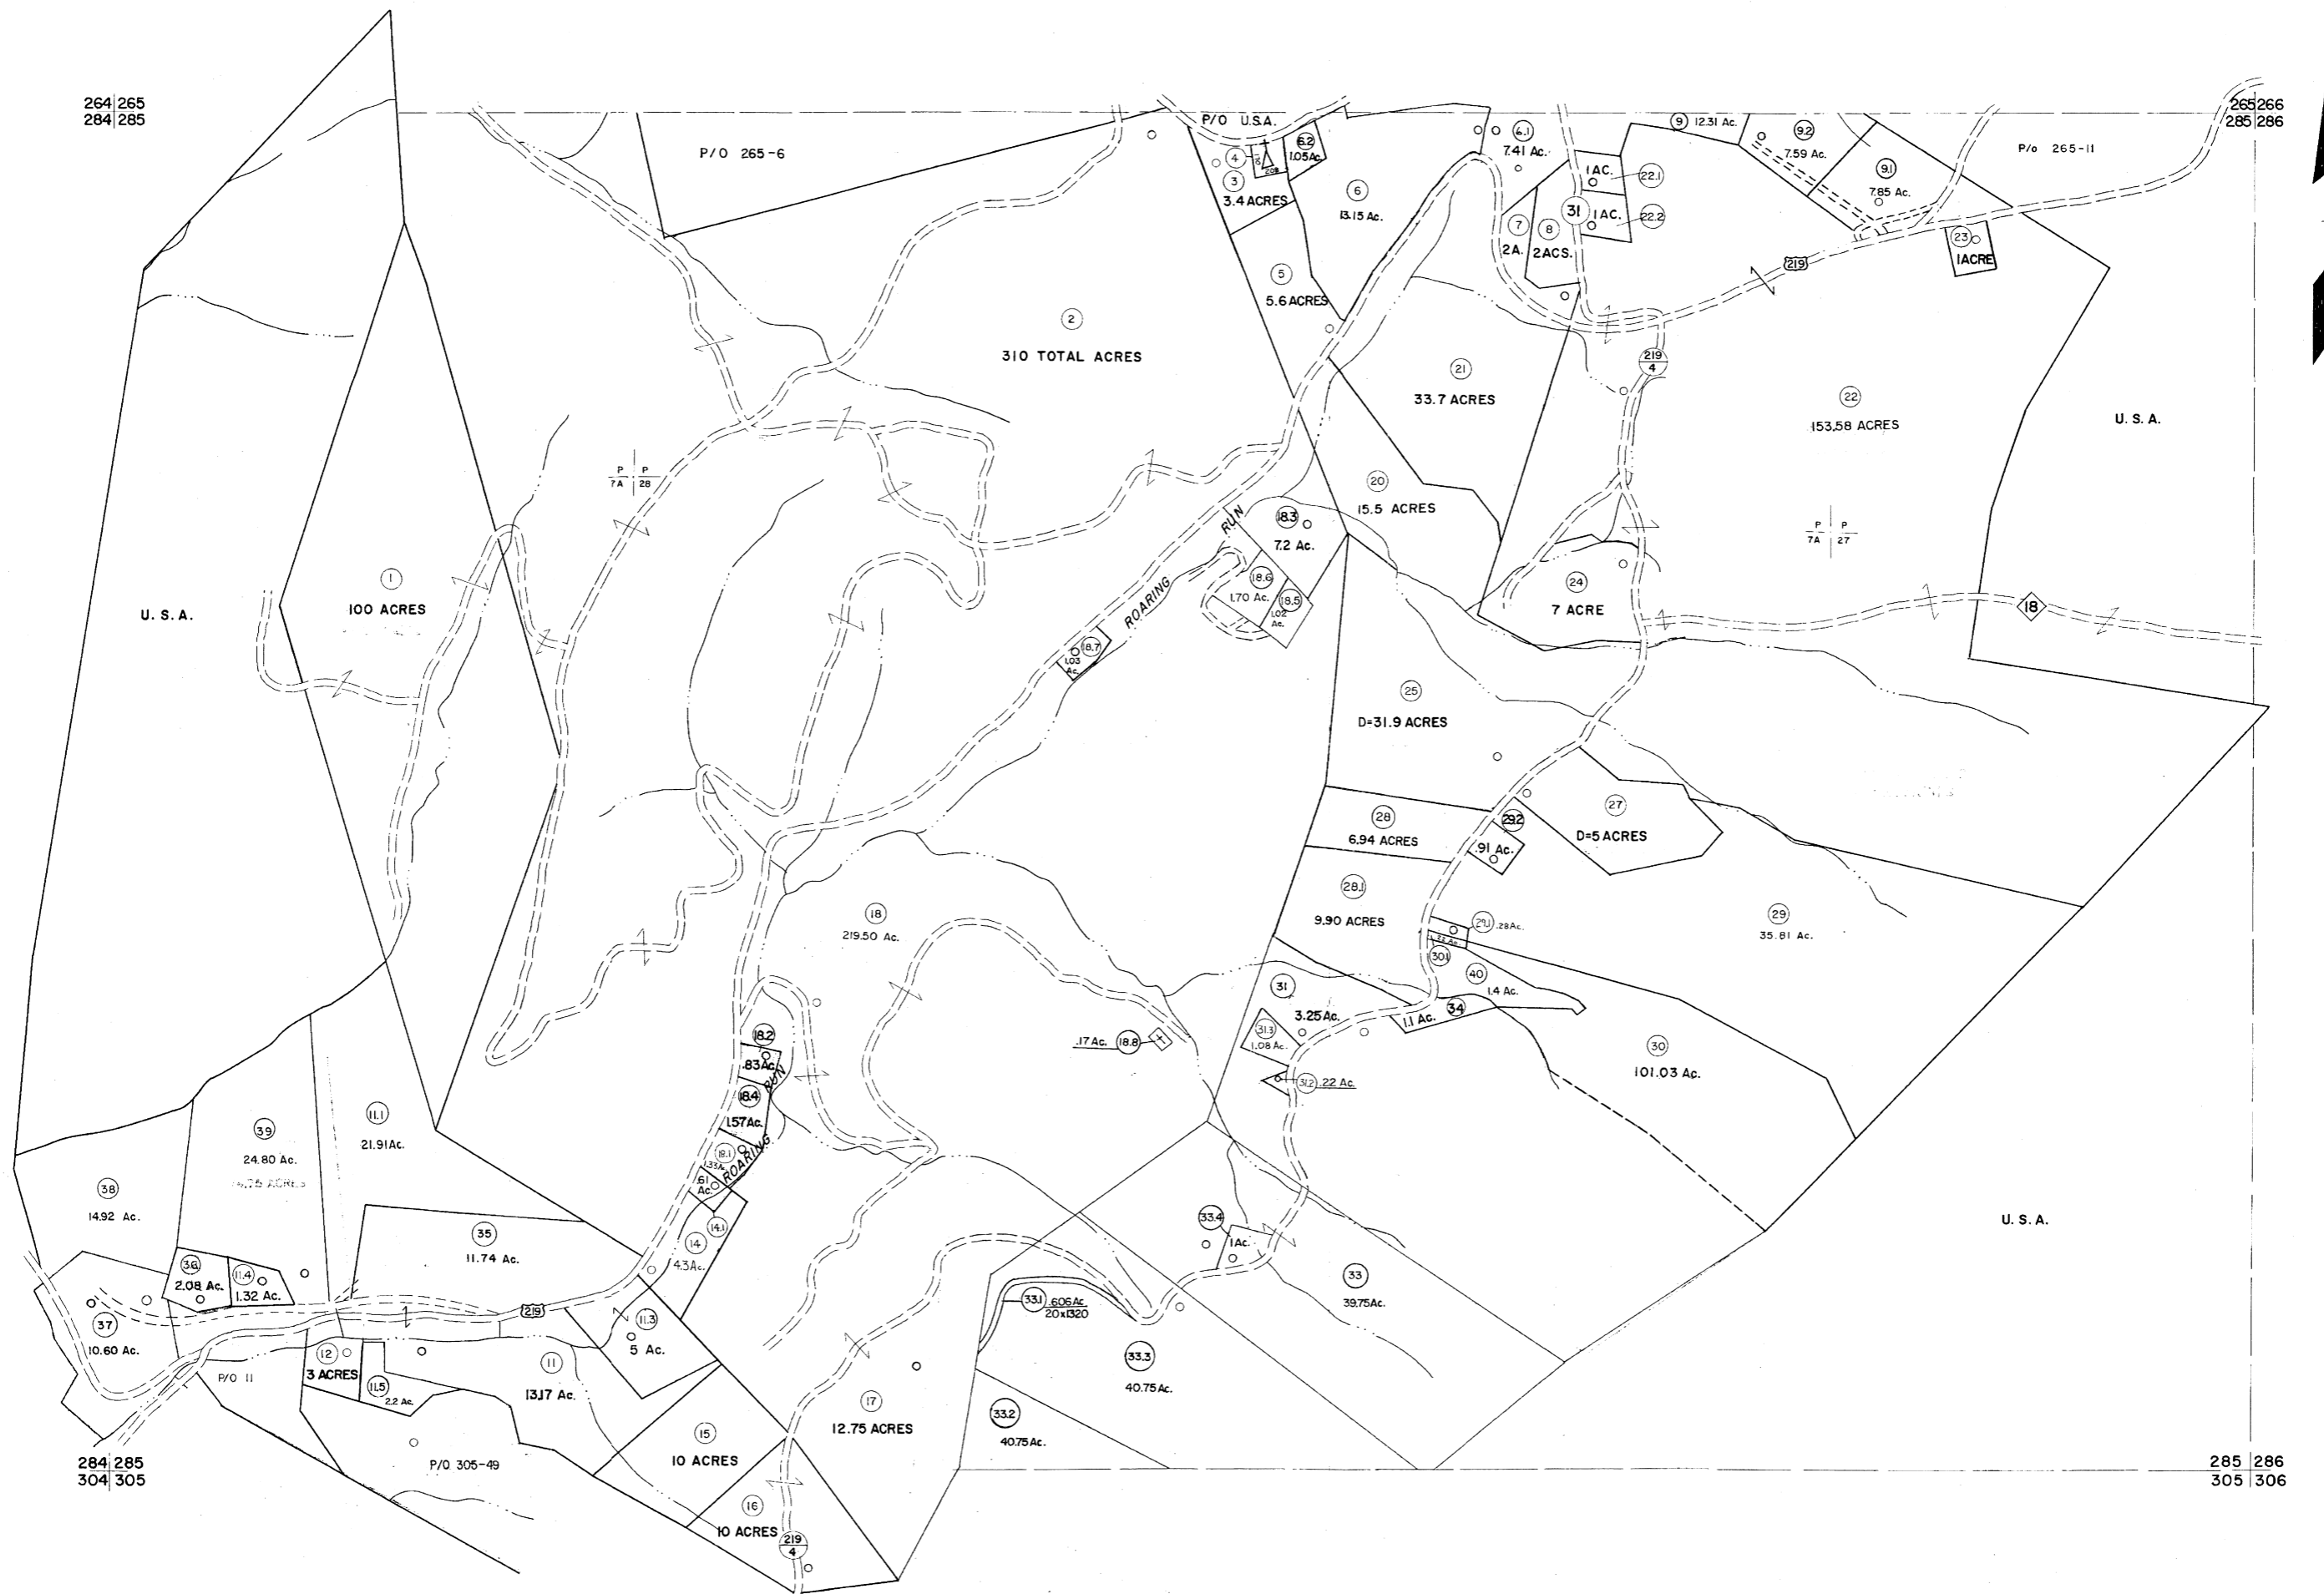

284 285
304 305


285 286
305 306

For Tax Purposes Only

Prepared by
MICHAEL BAKER, JR., INC.
Consulting Engineers
Rochester, Pennsylvania

Legend	
Property line	Original lot line
Edge of pavement or roadway	Dead lot number
Corporation line	Parcel or index number
District line	Improvement
County line	Railroad

Revisions			
1	10-3-63	9	OGIS 3-19-92 TL
2	6-4-75	10	OGIS 12/12/93 SAJ
3	11-27-78	11	O.S.I.S 4-1-96 J.E.B
4	Revised to 7-1-83	12	SLS INC. - DDC 5/97
5	7-1-84	13	SLS INC. 2/27/98 JWM
6	Revised to 3-1-89	14	SLS INC. 1/27/99 DSW
7	Revised to 3-1-89	15	SLS INC. 3/2/00 JWM
8	OGIS 1/1/91	16	ESI 2/1/01 REK

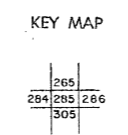

TUCKER COUNTY
STATE OF WEST VIRGINIA
Office of Assessor

DISTRICT BLACKFORK

SHEET NO: 285

Date, Aerial Photography: November, 1961 Date, Map: Dec, 1962
Photo No: Scale: 1" = 400'