


124 125

125

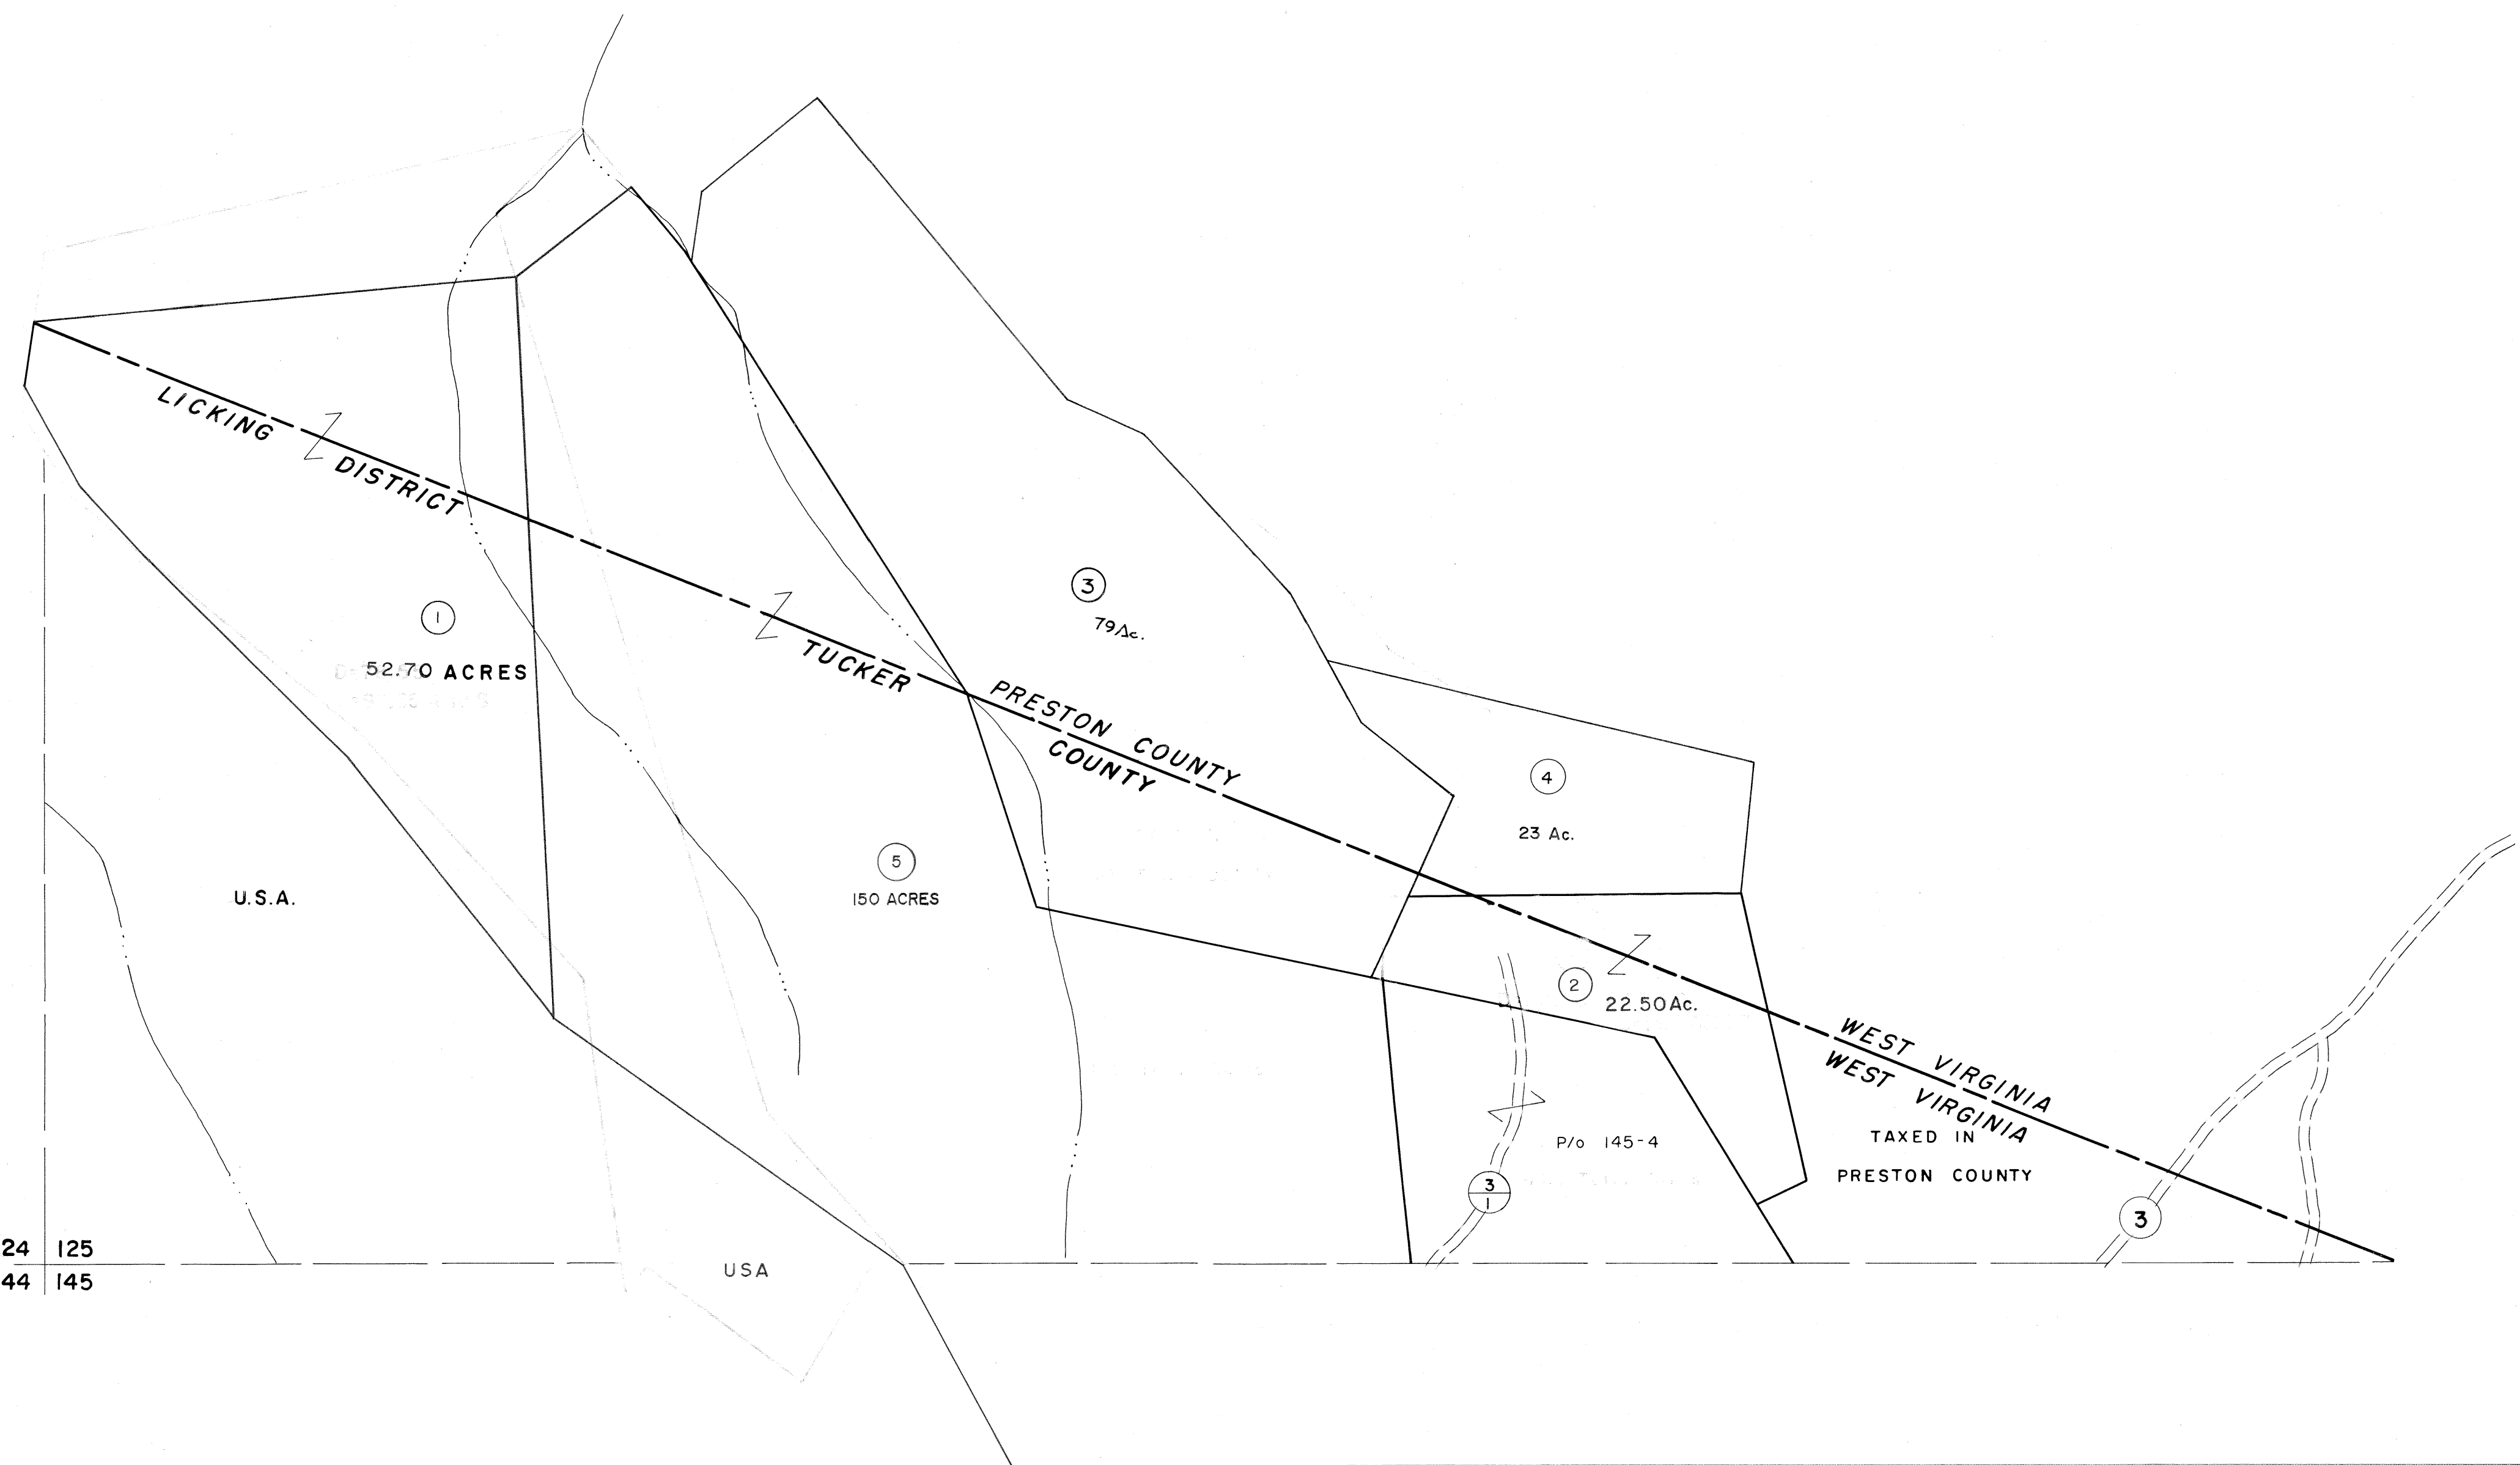

124 125  
144 145


125  
145 146

For Tax Purposes Only

Prepared by  
**MICHAEL BAKER, JR., INC.**  
 Consulting Engineers  
 Rochester, Pennsylvania

Legend	
Property line	Original lot line
Edge of pavement or roadway	Dead lot number
Corporation line	Parcel or index number
District line	Improvement
County line	Railroad

Revisions	
1	11/14/78 D.G. SLS INC. - DDC 5/97
2	Revised to 7-1-84 L.E.S.
3	7-1-84 L.E.S.
4	OGIS 12/29/90 DSH
5	OGIS 1/23/93 DSH
6	OGIS 12/9/93 SAJ

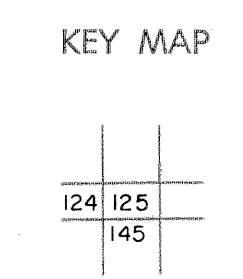

**TUCKER COUNTY**  
 STATE OF WEST VIRGINIA  
 Office of Assessor

DISTRICT	LICKING
SHEET NO:	125
Date, Aerial Photography:	November, 1961
Date, Map:	Dec, 1962
Photo No:	Scale: 1" = 400'