


322 323  
342 343

323 324  
343 344

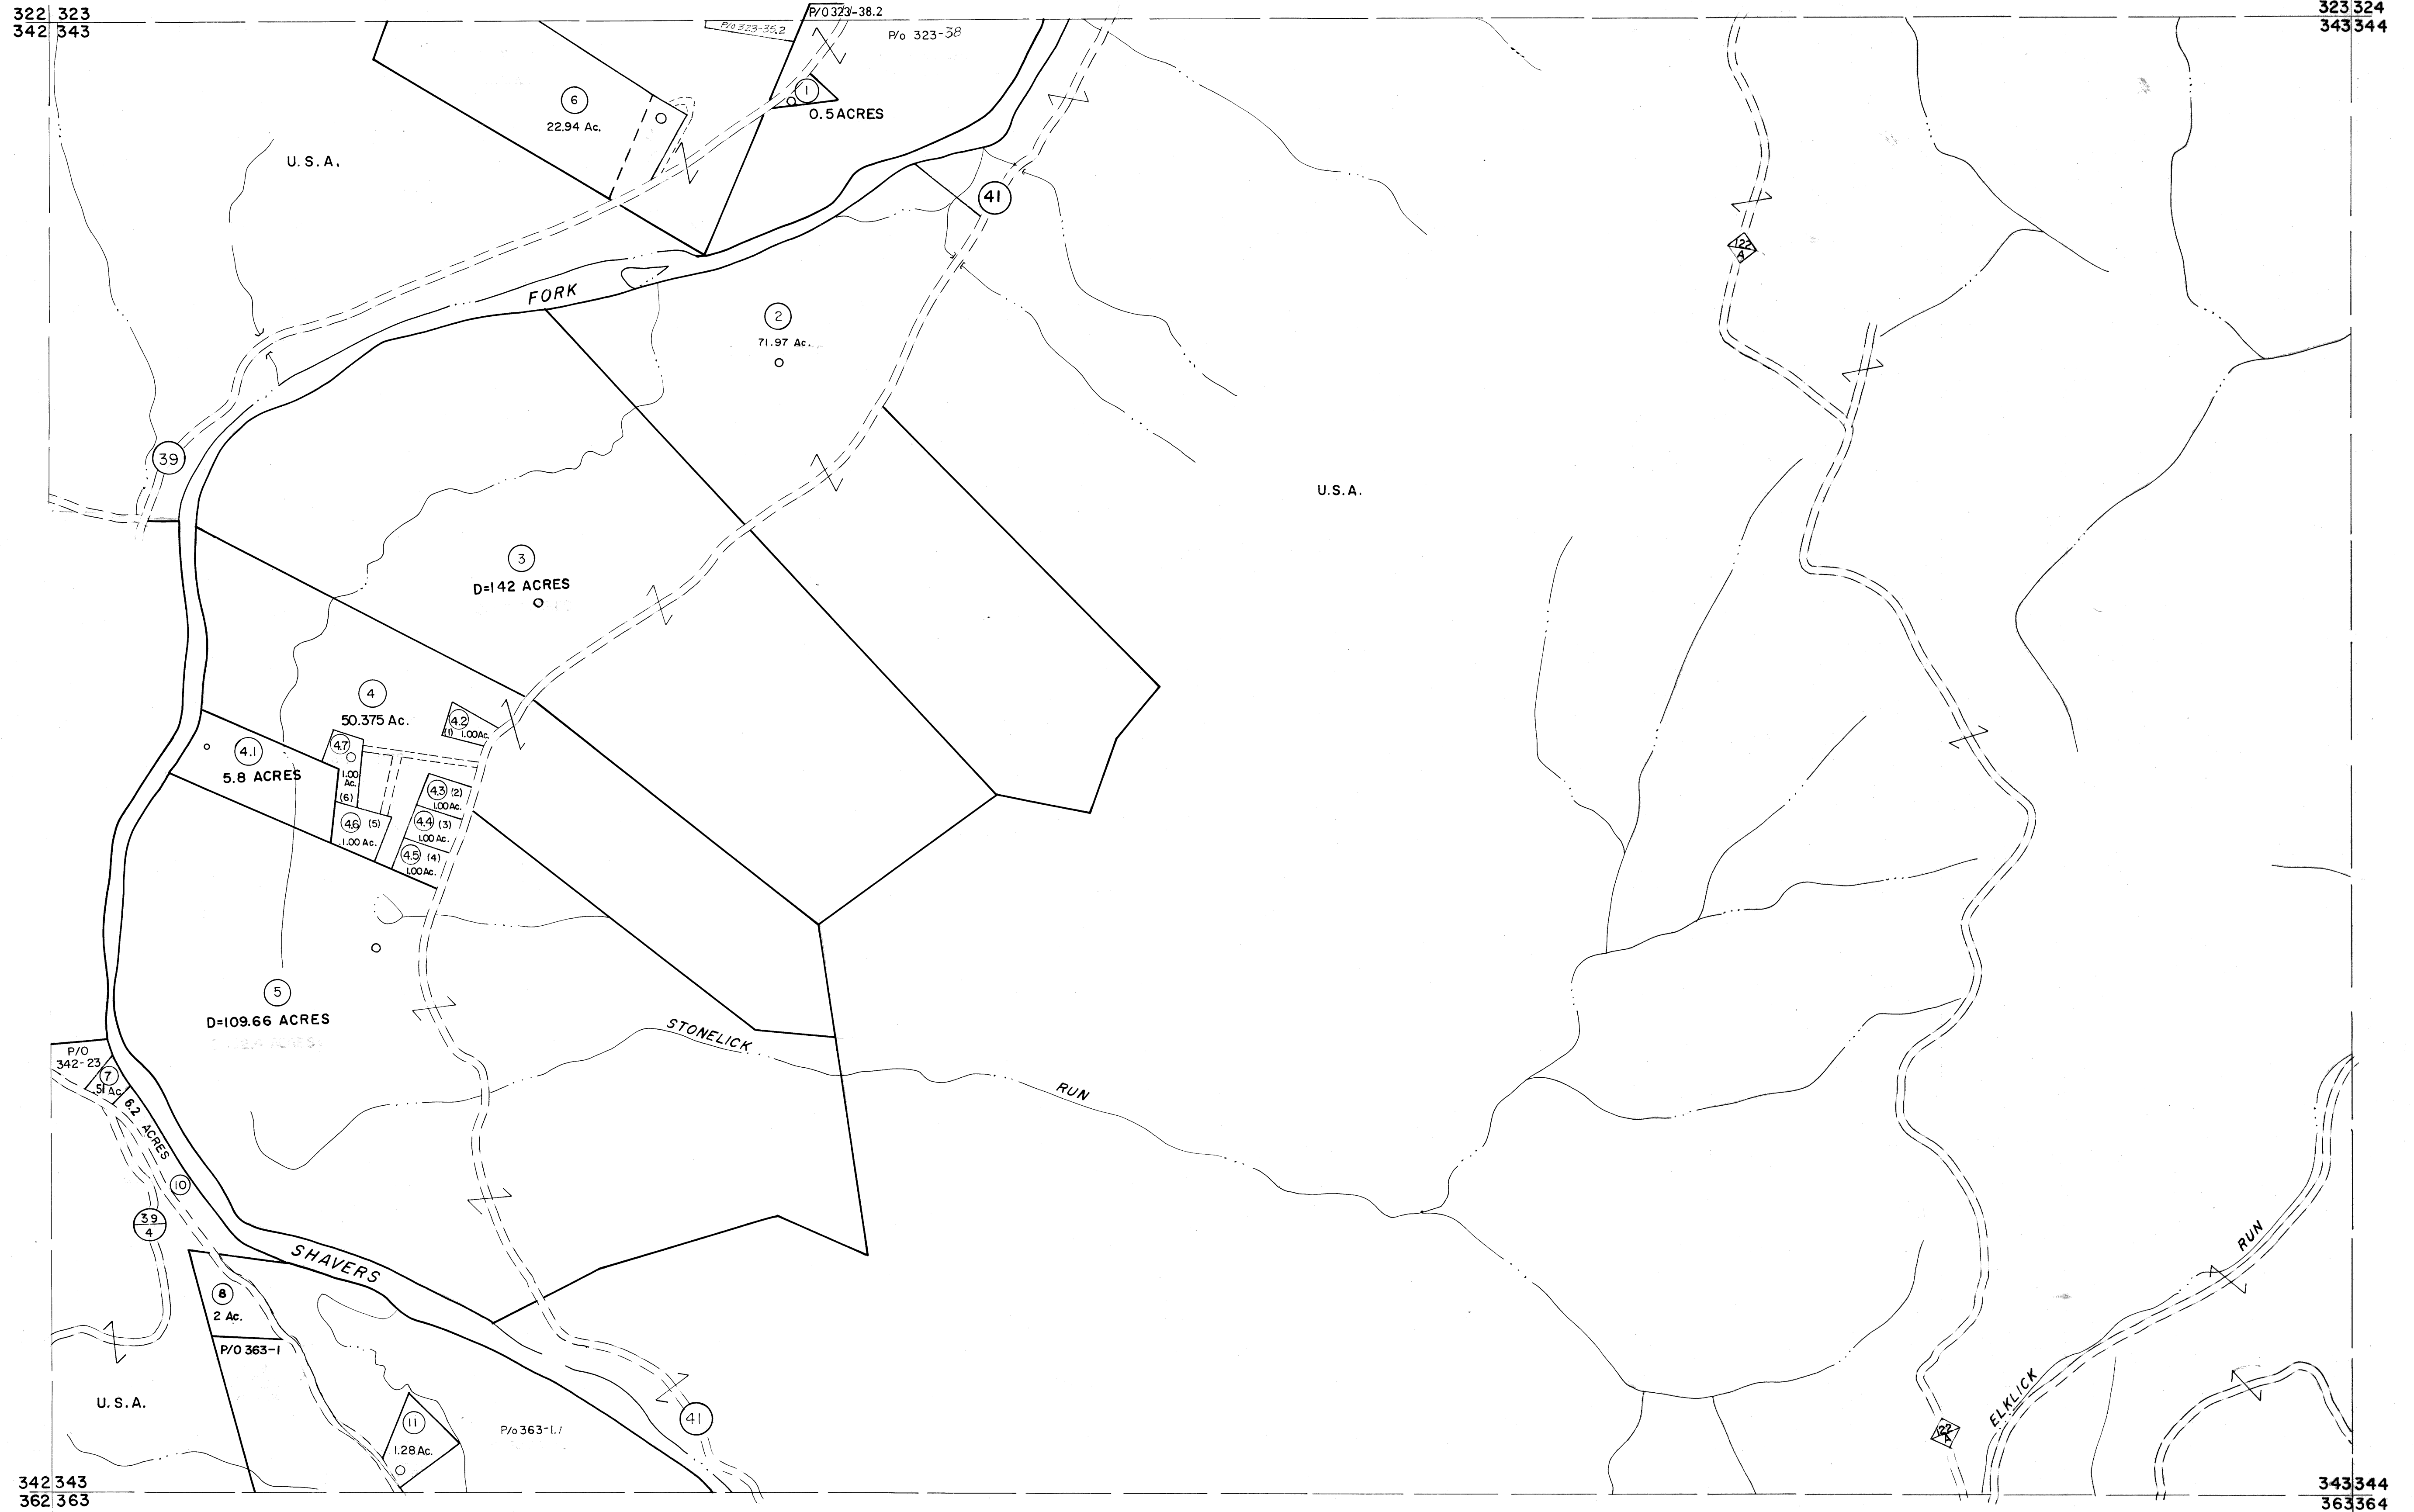

For Tax Purposes Only

Prepared by  
MICHAEL BAKER, JR., INC.  
Consulting Engineers  
Rochester, Pennsylvania


Legend

Property line	—	Original lot line	- - - - -
Edge of pavement or roadway	—	Deed lot number	(15)
Corporation line	—	Parcel or index number	(39)
District line	—	Improvement	o
County line	—	Railroad	—+—

Revisions

1	1/2-78	BAH	9	ESI	2/12/02	REK	17
2	Revised to 7-1-83	DL	10	ESI	2/20/03	REK	18
3	May 1985	JRL	11				19
4	Revised to 7-1-87	DL	12				20
5	OGIS 1/5/91	DSH	13				21
6	OGIS 3-19-92	TL	14				22
7	O.G.I.S. 4-1-96	J.E.B	15				23
8	SLS INC. - DDC	5/97	16				24

KEY MAP

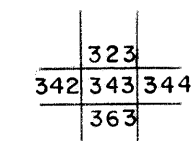

TUCKER COUNTY  
STATE OF WEST VIRGINIA  
Office of Assessor

DISTRICT

BLACKFORK

SHEET NO: 343

Date, Aerial Photography: November, 1961 Date, Map: Dec., 1962  
Photo No: Scale: 1" = 400'