


322 323  
342 343

323 324  
343 344

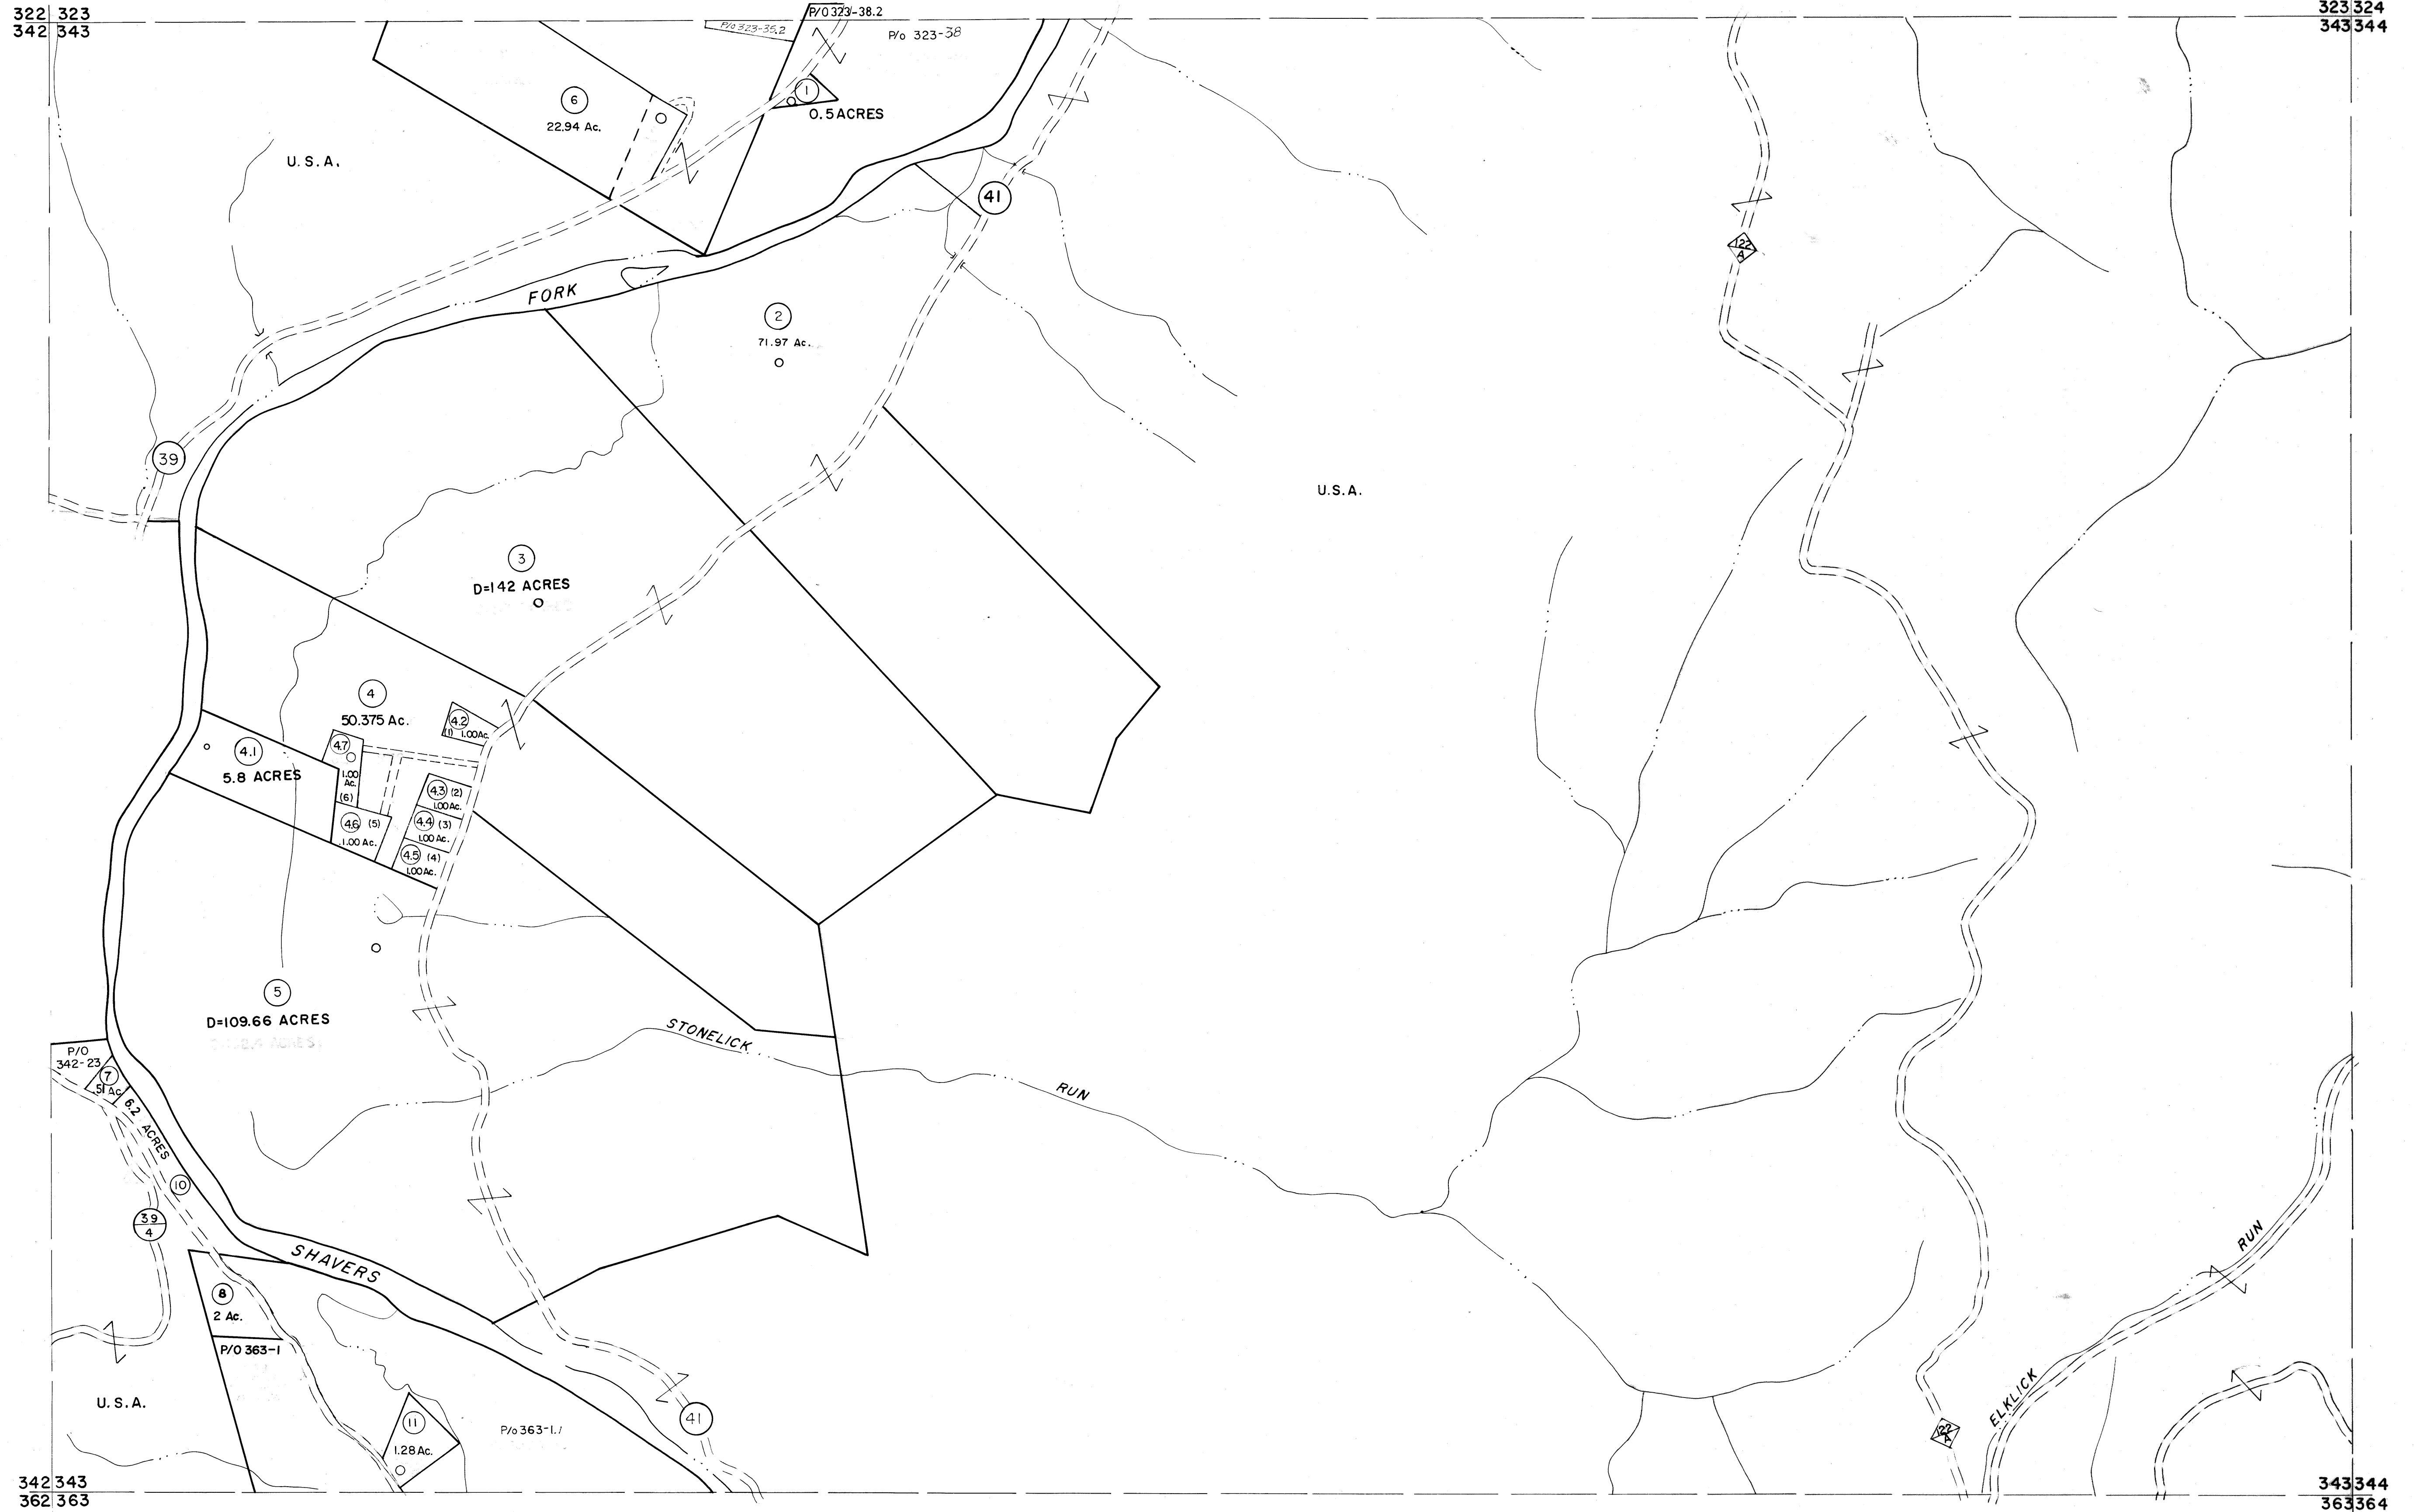

For Tax Purposes Only  
 Prepared by  
**MICHAEL BAKER, JR., INC.**  
 Consulting Engineers  
 Rochester, Pennsylvania

Legend	
Property line	Original lot line
Edge of pavement or roadway	Deed lot number (15)
Corporation line	Parcel or index number (39)
District line	Improvement (o)
County line	Railroad

Revisions			
1	1/2-78 BAH	9	ESI 2/12/02 REK 17
2	Revised to 7-1-83	10	ESI 2/20/03 REK 18
3	May 1985	11	
4	Revised to 7-1-87	12	
5	OGIS 1/5/91 DSH	13	
6	OGIS 3-19-92 TL	14	
7	O.G.I.S. 4-1-96 J.E.B	15	
8	SLS INC. - DDC 5/97	16	

KEY MAP

**TUCKER COUNTY**  
 STATE OF WEST VIRGINIA  
 Office of Assessor

DISTRICT  
**BLACKFORK**  
**SHEET NO: 343**  
 Date, Aerial Photography: November, 1961 Date, Map: Dec., 1962  
 Photo No: Scale: 1" = 400'