


342343
362363

343344
363364

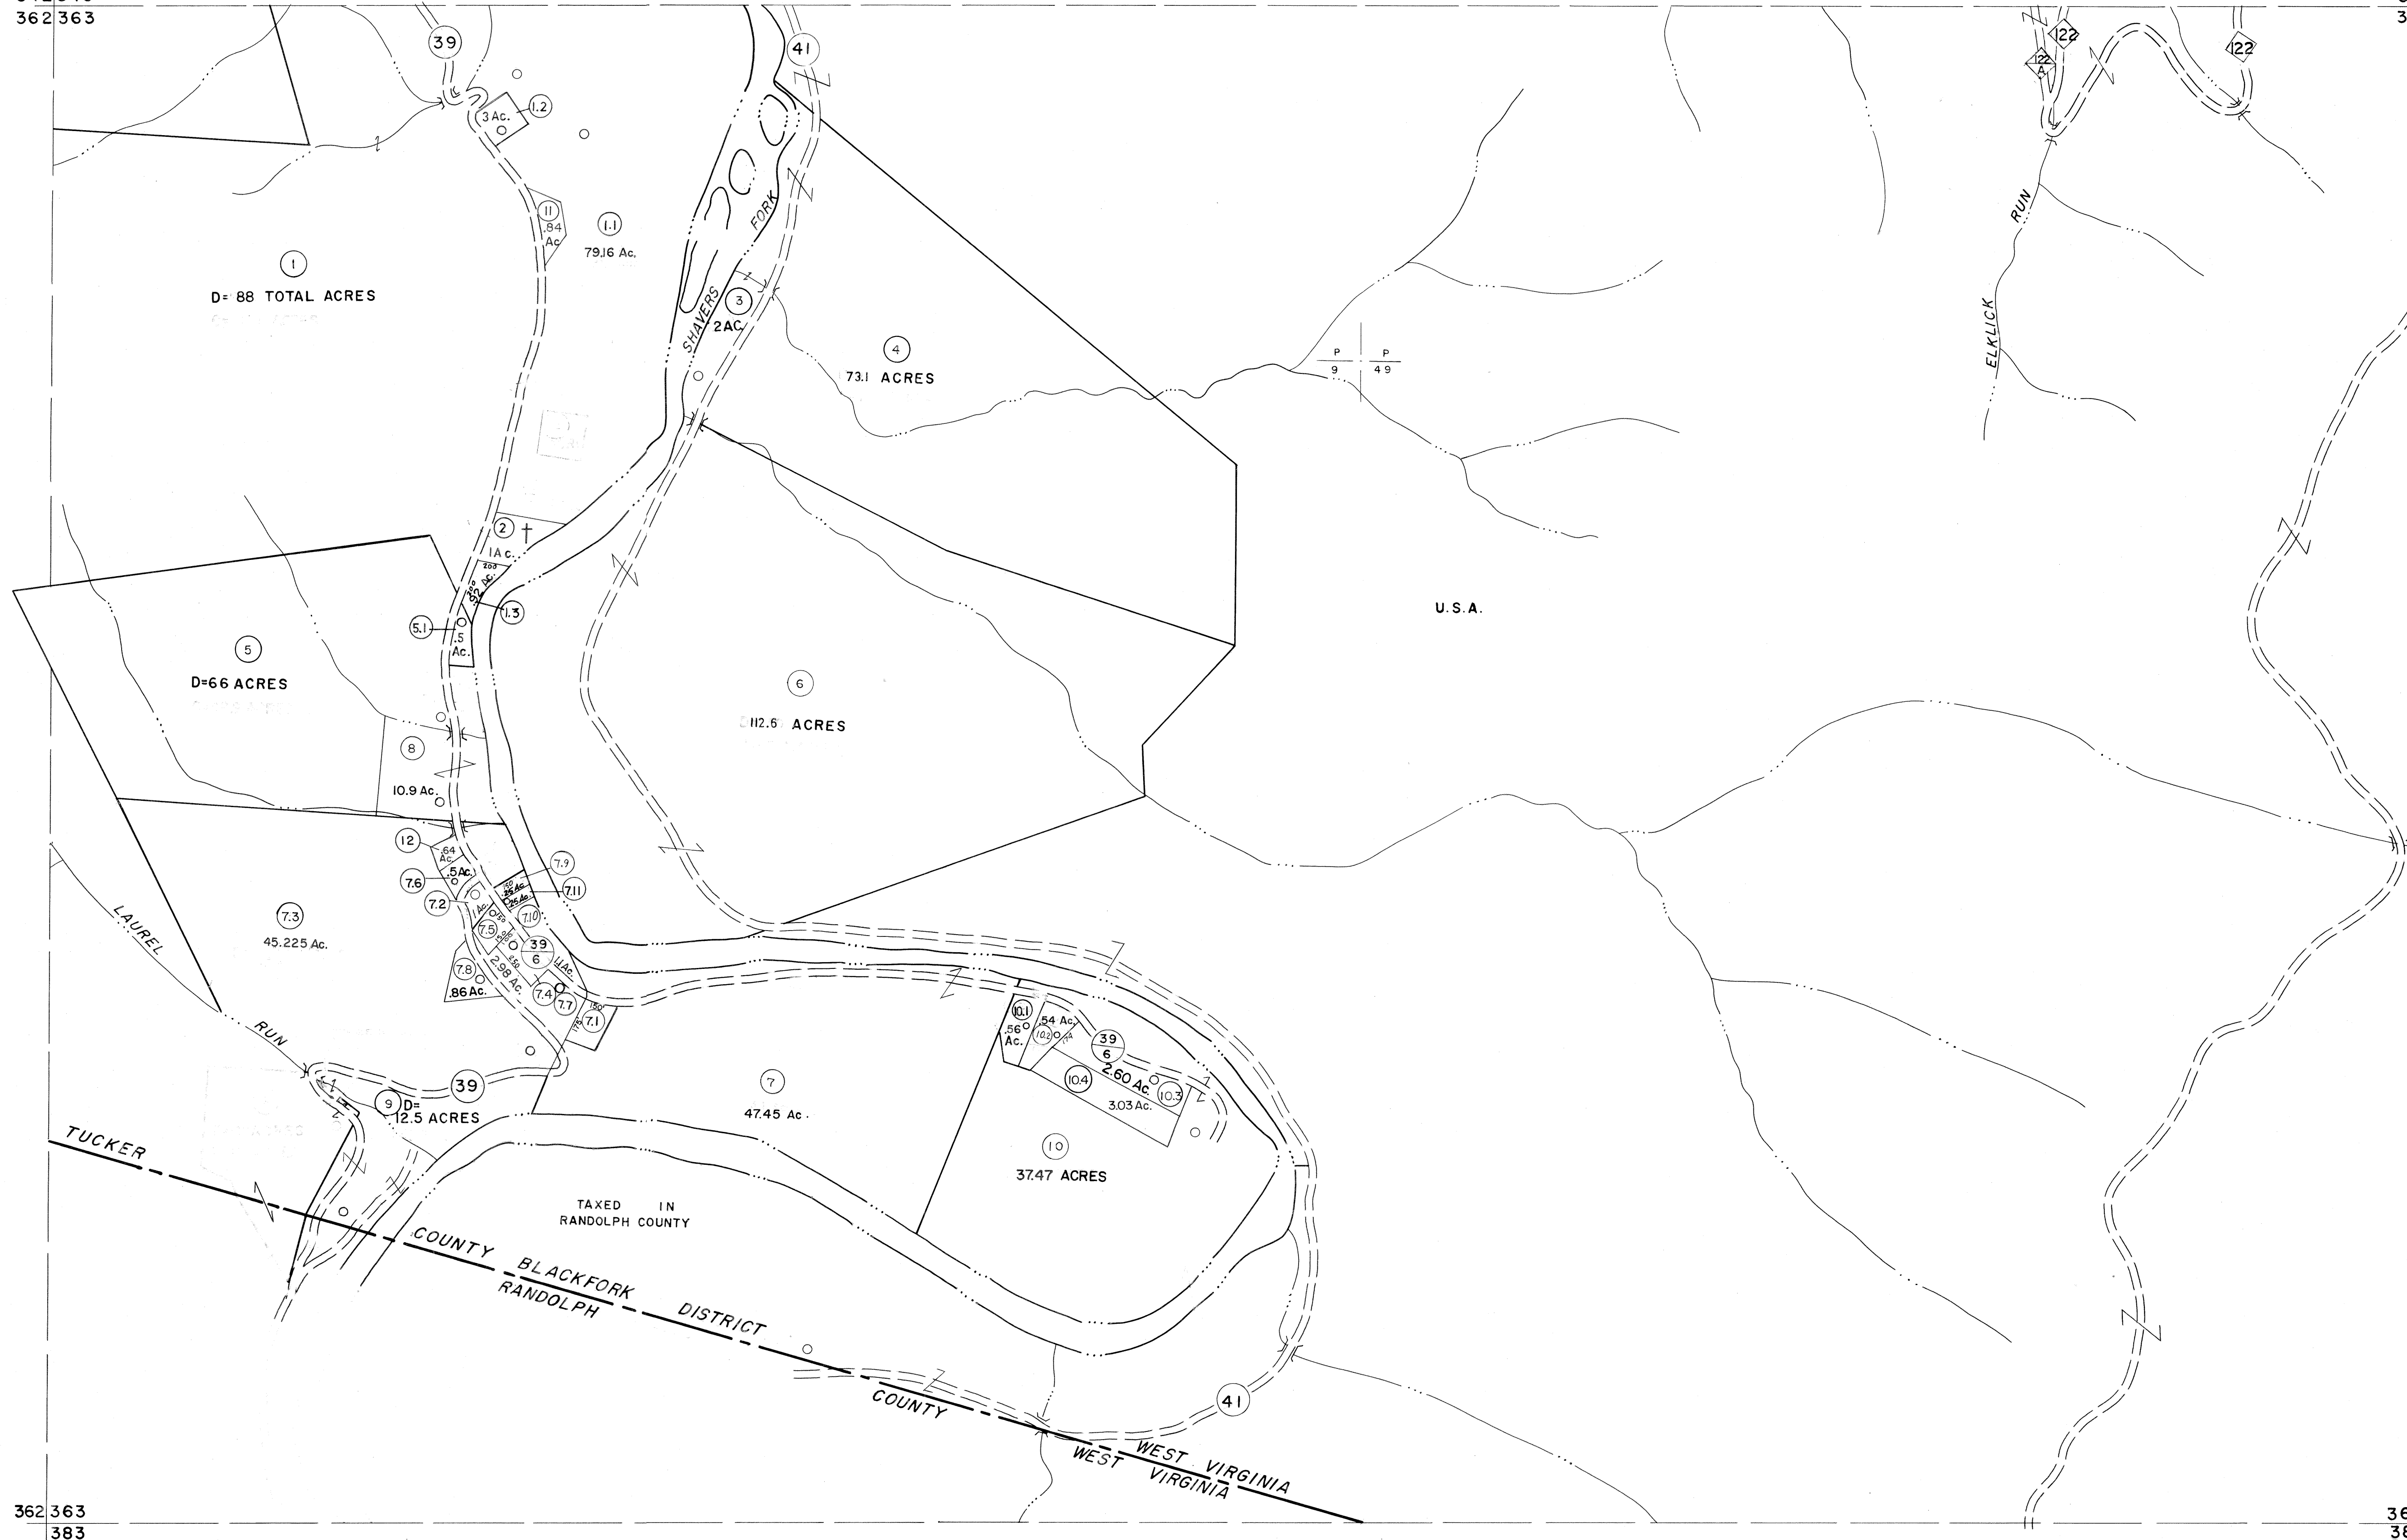

362363
383

363364
383384

For Tax Purposes Only

Prepared by
MICHAEL BAKER, JR., INC.
Consulting Engineers
Rochester, Pennsylvania


Legend

Property line	—	Original lot line	- - - -
Edge of pavement or roadway	—	Deed lot number	(15)
Corporation line	—	Parcel or index number	(39)
District line	—	Improvement	○
County line	—	Railroad	—

Revisions

No.	Date	By	Description
1	6-3-75	J.C.	OGIS
2	11/22/78	D.G.	SLS INC. - DDC 5/97
3	Revised to 7-1-88	L.E.S.	ES1 2/2/01 REK
4	7-1-84	L.E.S.	3/28/06 S&H
5	Revised to 7-1-87	R.E.B.	
6	Rev. to 3-1-89	R.E.B.	
7	OGIS 1/6/91	DSH	
8	OGIS 3-19-92	TL	

KEY MAP

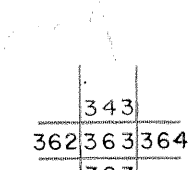

TUCKER COUNTY

STATE OF WEST VIRGINIA

Office of Assessor

DISTRICT

BLACKFORK

SHEET NO: 363

Date, Aerial Photography: November, 1961 Date, Map: Dec, 1962
Photo No: Scale: 1" = 400'