


124 125

125

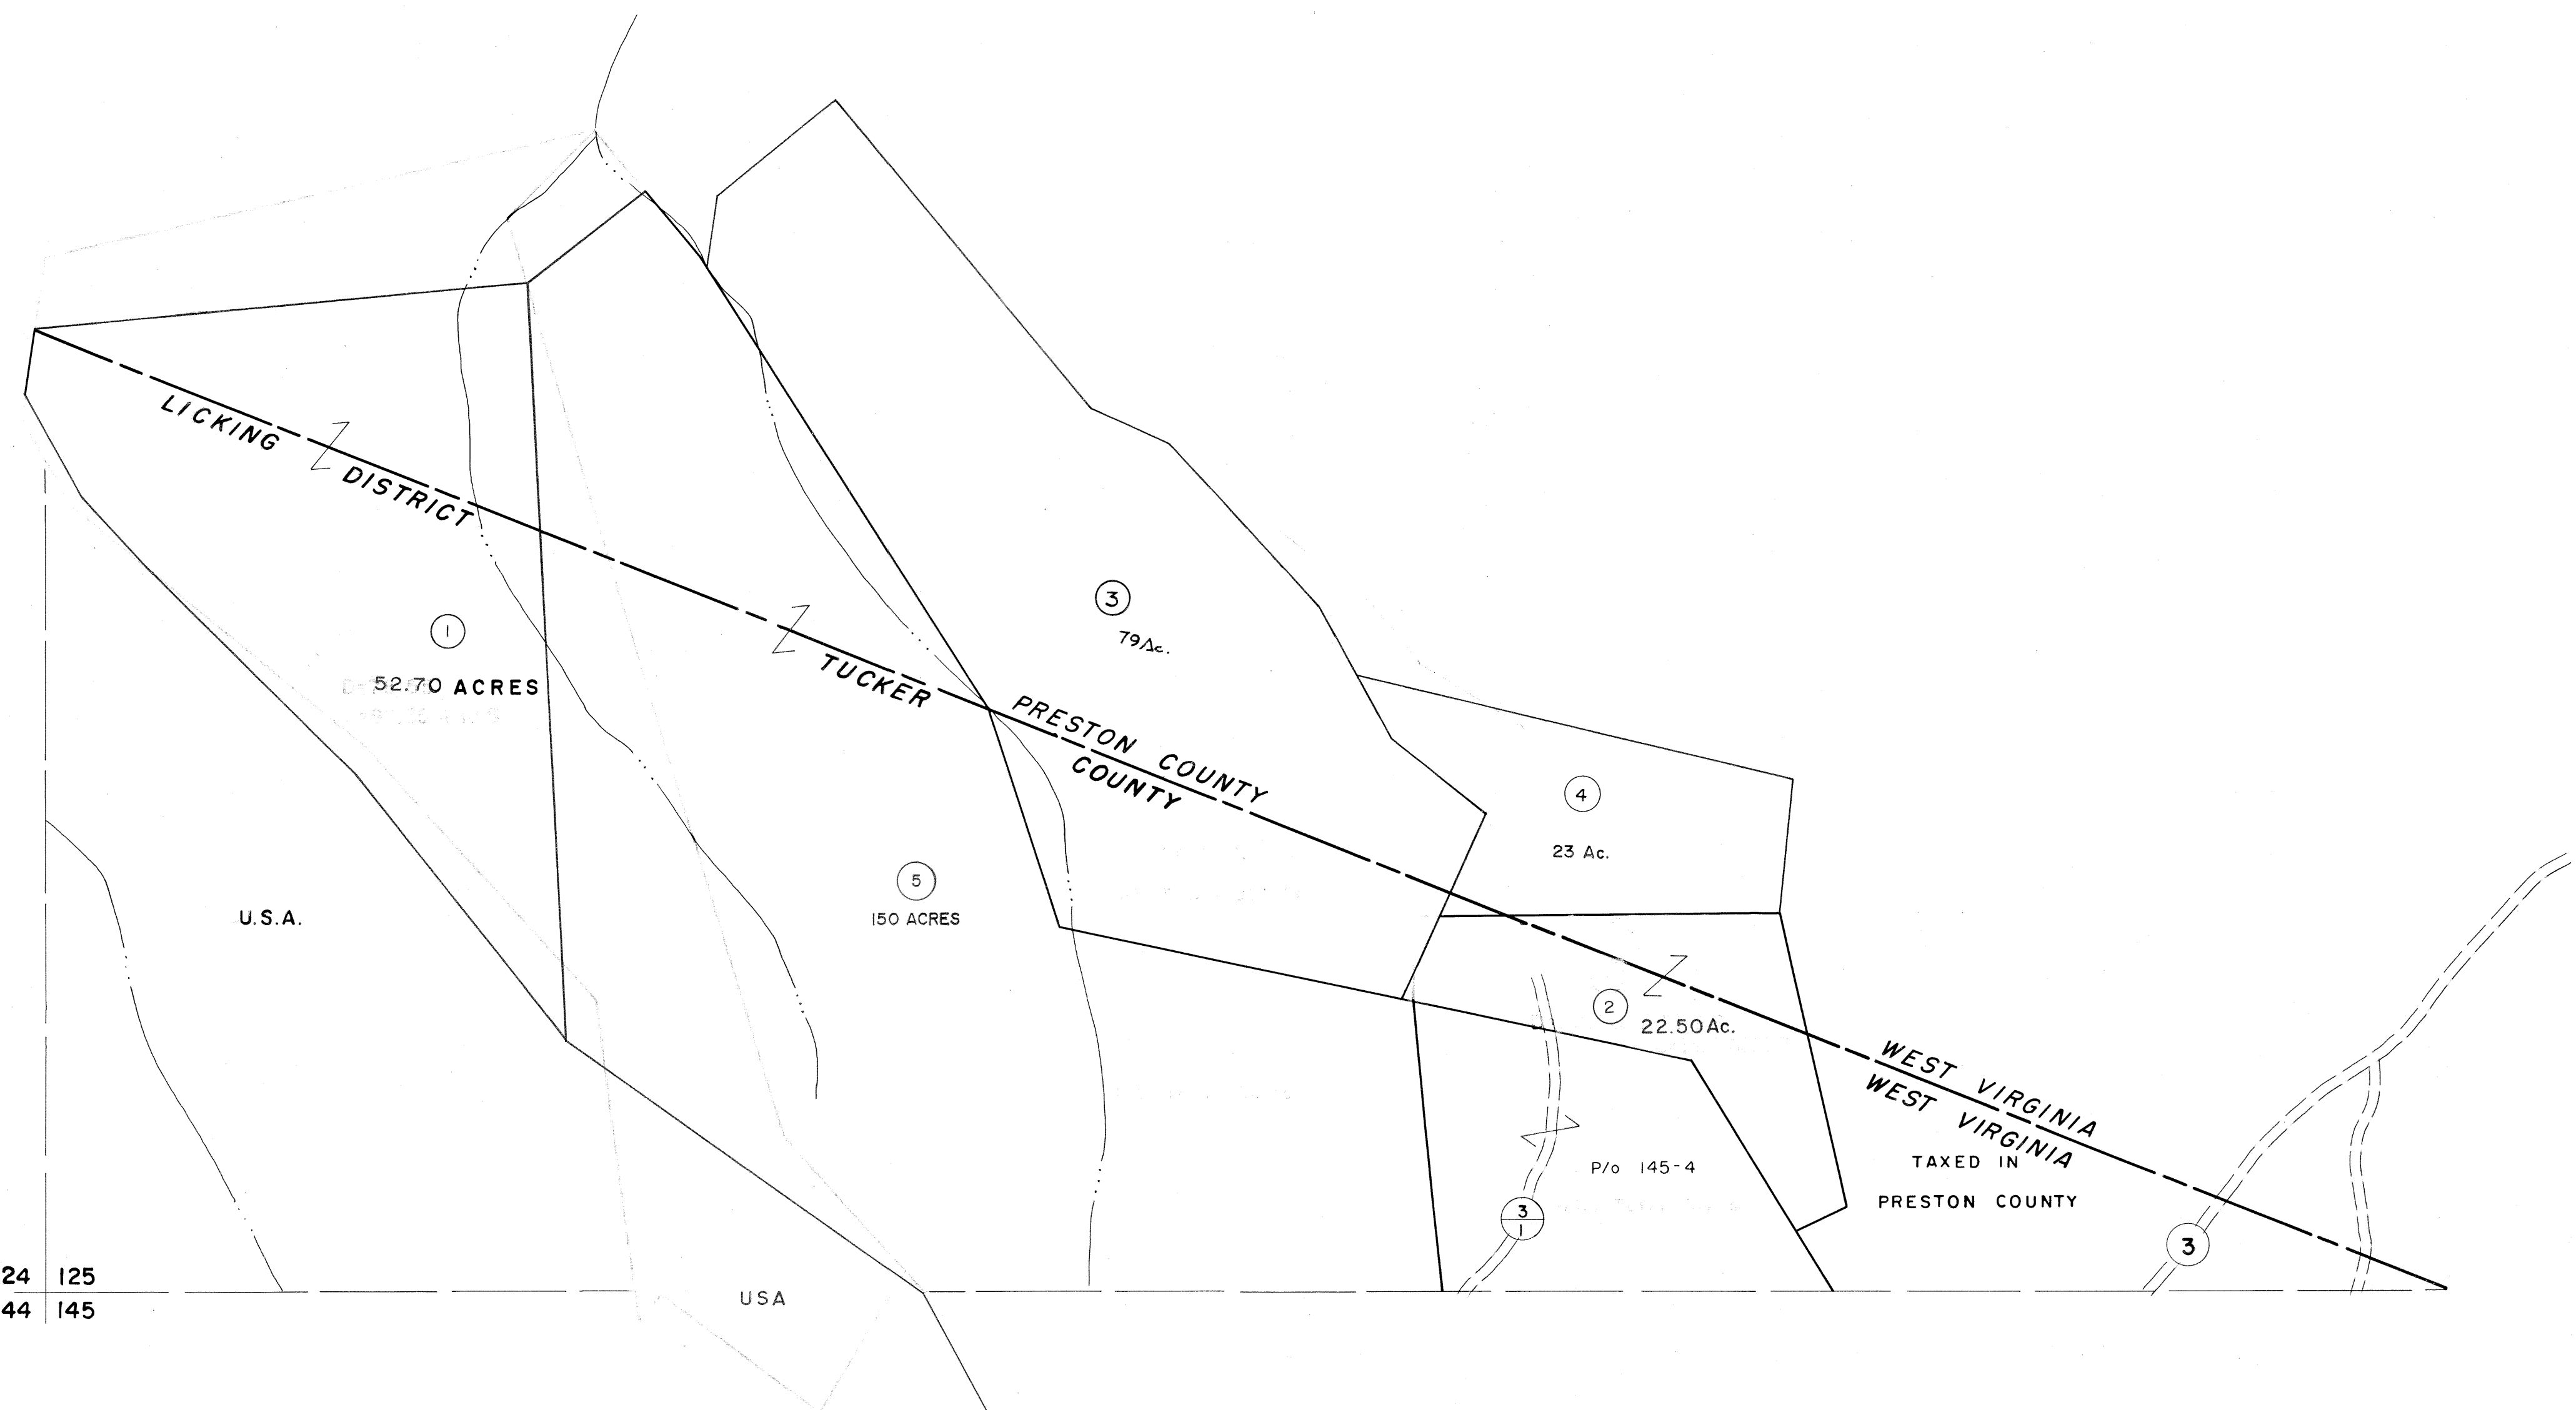

124 125  
144 145

125  
145 146

For Tax Purposes Only

Prepared by  
**MICHAEL BAKER, JR., INC.**  
 Consulting Engineers  
 Rochester, Pennsylvania

Legend	
Property line	Original lot line
Edge of pavement or roadway	Dead lot number
Corporation line	Parcel or index number
District line	Improvement
County line	Railroad

Revisions	
1	11/14/78 DGL SLS INC. - DDC 5/97
2	Revised to 7-1-84 L.E.S.
3	7-1-84 L.E.S.
4	OGIS 12/29/90 DSH
5	OGIS 1/23/93 DSH
6	OGIS 12/9/93 SAJ
7	
8	

KEY MAP

**TUCKER COUNTY**  
 STATE OF WEST VIRGINIA  
 Office of Assessor

DISTRICT  
**LICKING**

SHEET NO: 125

Date, Aerial Photography: November, 1961 Date, Map: Dec, 1962  
 Photo No: Scale: 1" = 400'