


200
220

220
240

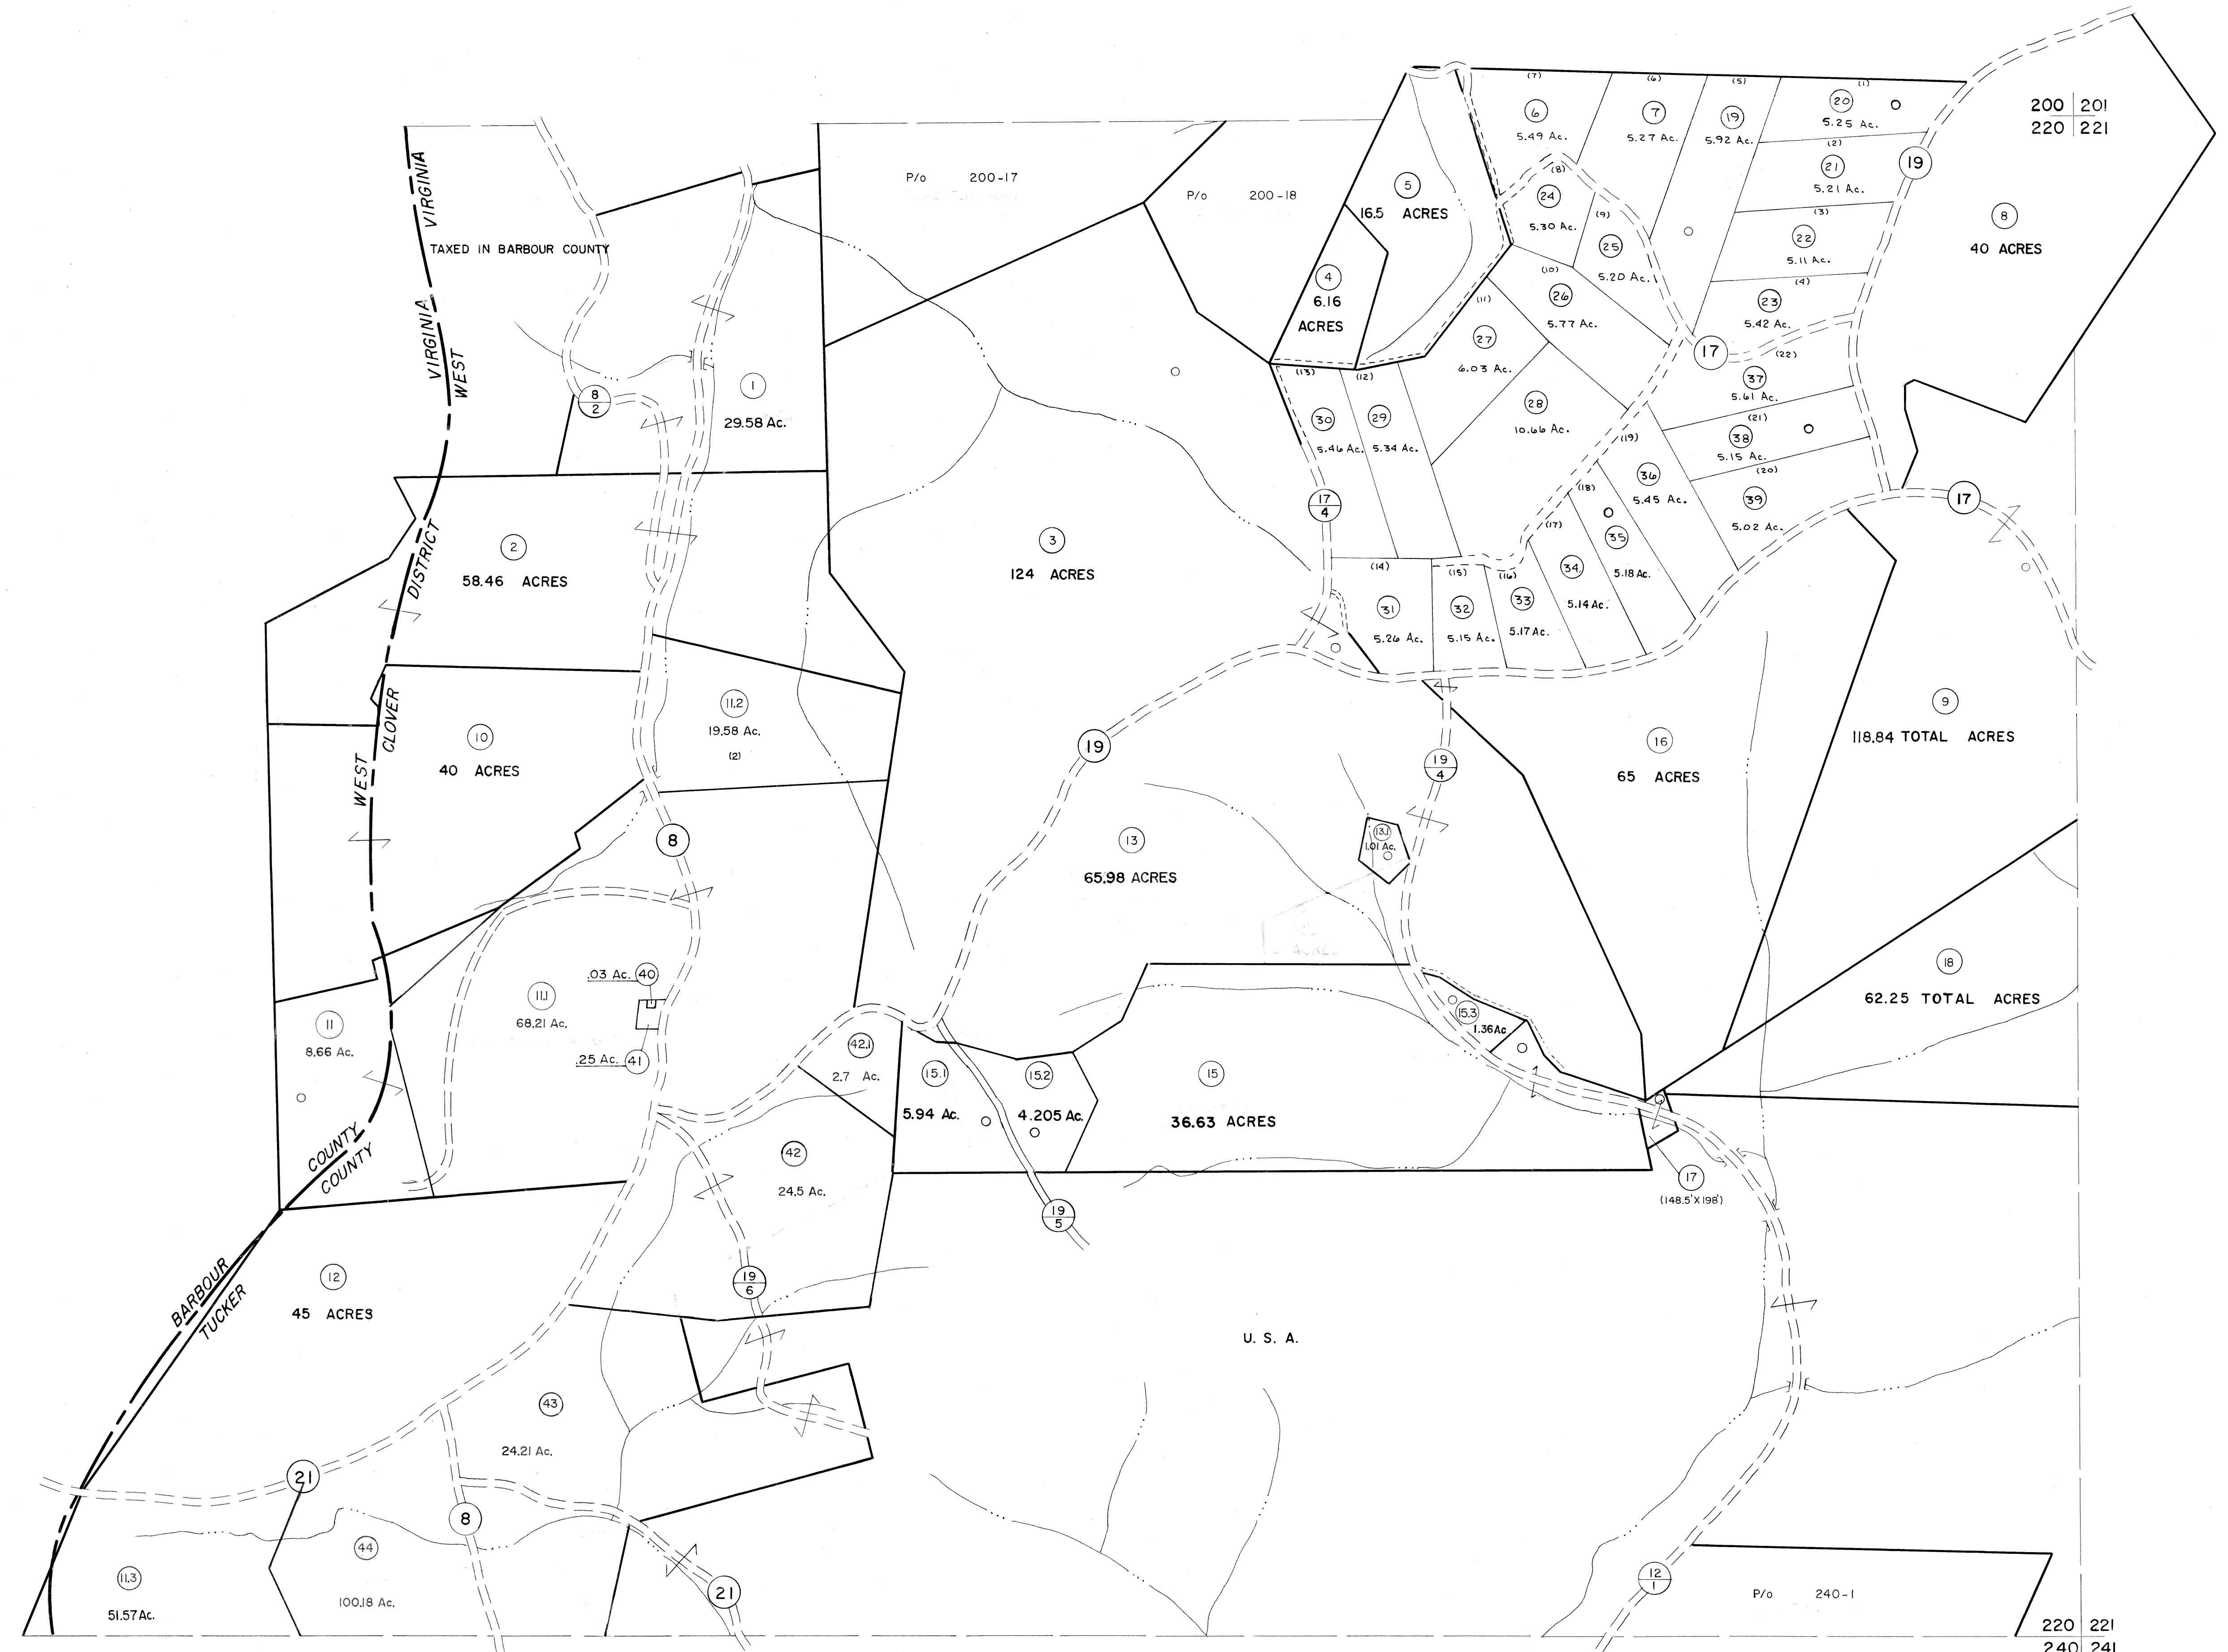

220 221
240 241

For Tax Purposes Only

Prepared by
MICHAEL BAKER, JR., INC.
 Consulting Engineers
 Rochester, Pennsylvania

Legend	
Property line	Original lot line
Edge of pavement or roadway	Deed lot number
Corporation line	Parcel or index number
District line	Improvement
County line	Railroad

Revisions	
1 6-3-75 JC	9 OGIS 4-95 HD 17
2 11-1-83 JC	10 SLS INC. - DDC 5/97 18
3 7-1-85 JC	11 SLS INC. 2/23/98 JWM 19
4 REV. TO 7-1-86 NCS	12 SLS INC. 1/27/99 DSW 20
5 Rev. to 3-1-89 R.E.B.	13 ESI 1/31/01 REK 21
6 OGIS 3-19-92 T.L.	14 HBS 2/22/04 22
7 OGIS 1/25/93 DSH	15 23
8 OGIS 12/11/93 SAJ	16 24

KEY MAP

TUCKER COUNTY
 STATE OF WEST VIRGINIA
 Office of Assessor

DISTRICT
CLOVER

SHEET NO: 220

Date, Aerial Photography: November, 1961 Date, Map: Dec., 1962
 Photo No: Scale: 1" = 400'