 


204 205  
224 225

205 206  
225 226



224 225  
244 245

225 226  
245 246

For Tax Purposes Only

Prepared by  
MICHAEL BAKER, JR., INC.  
Consulting Engineers  
Rochester, Pennsylvania


Legend

Property line	—	Original lot line	- - - - -
Edge of pavement or roadway	—	Deed lot number	(15)
Corporation line	—	Parcel or index number	(99)
District line	—	Improvement	o
County line	—	Railroad	+

Revisions

1	6-3-75	Jc	9	OGIS	2-95	HD	17
2	11-21-78	DA	10	SLS INC.	DDC 5/97		18
3	Revised to 7-1-85		11	SLS INC.	1/27/99	DSW	19
4	REV. TO 7-1-86	NCS	12	ES1	1/31/01	REK	20
5	REV. TO 3-1-89	R.E.B.	13	ES1	2/7/02	REK	21
6	OGIS 3-19-92	TL	14		3/21/05	S.B.H.	22
7	OGIS 1/25/93	DSH	15		3/24/07	S.B.H.	23
8	OGIS 12/11/93	SAJ	16				24

KEY MAP

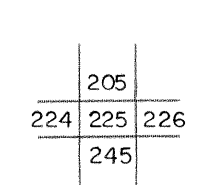

TUCKER COUNTY  
STATE OF WEST VIRGINIA  
Office of Assessor

DISTRICT  
ST. GEORGE

SHEET NO: 225

Date, Aerial Photography: Nov., 1961 Date, Map: Dec., 1962  
Photo No: Scale: 1" = 400'