


322 323
342 343

323 324
343 344

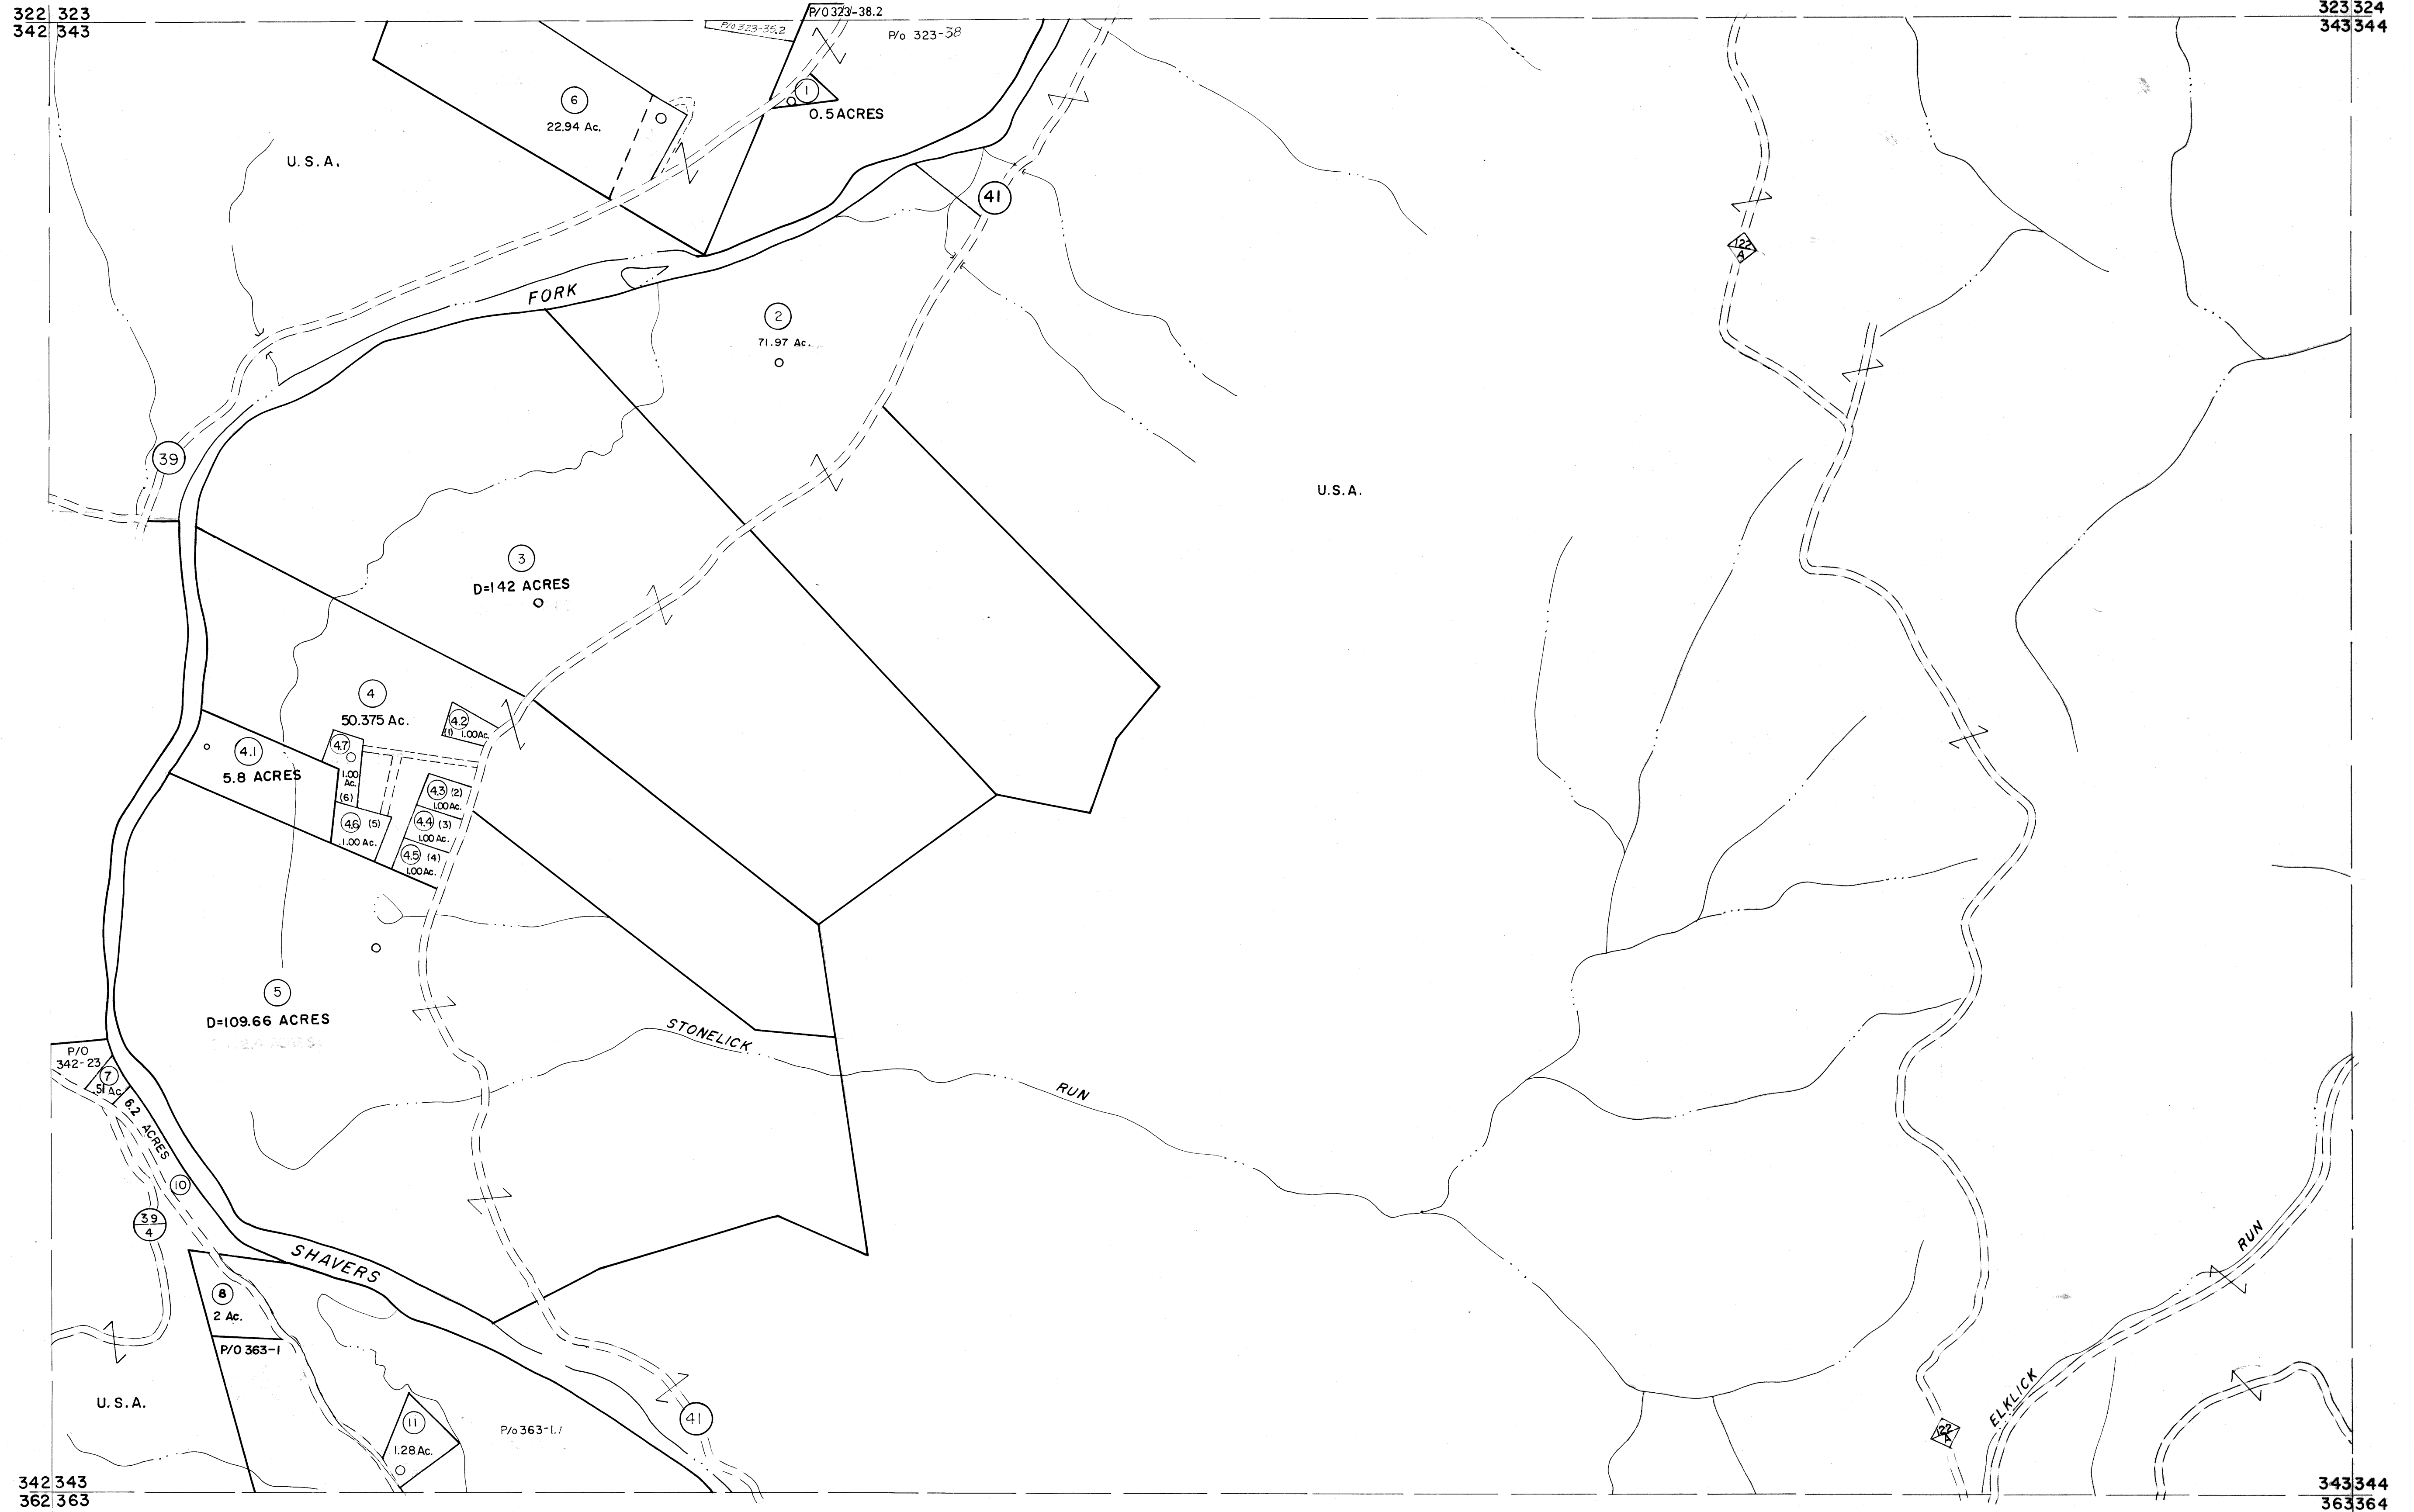

For Tax Purposes Only

Prepared by
MICHAEL BAKER, JR., INC.
Consulting Engineers
Rochester, Pennsylvania


Legend

Property line	—————	Original lot line	-----
Edge of pavement or roadway	-----	Deed lot number	(15)
Corporation line	-----	Parcel or index number	(39)
District line	-----	Improvement	o
County line	-----	Railroad	+

Revisions

No.	Description	Date	By	Checked
1	1/1-78 BAH	9	ESI	2/12/02 REK
2	Revised to 7-1-83	10	ESI	2/20/03 REK
3	July 1985	11		
4	Revised to 7-1-87	12		
5	OGIS 1/5/91	13	DSH	
6	OGIS 3-19-92	14	TL	
7	O.G.I.S. 4-1-96	15	J.E.B	
8	SLS INC. - DDC	5/97		

KEY MAP

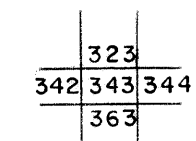

TUCKER COUNTY
STATE OF WEST VIRGINIA
Office of Assessor

DISTRICT

BLACKFORK

SHEET NO: 343

Date, Aerial Photography: November, 1961 Date, Map: Dec., 1962
Photo No: Scale: 1" = 400'