


347 348
367 368

348 349
368 369

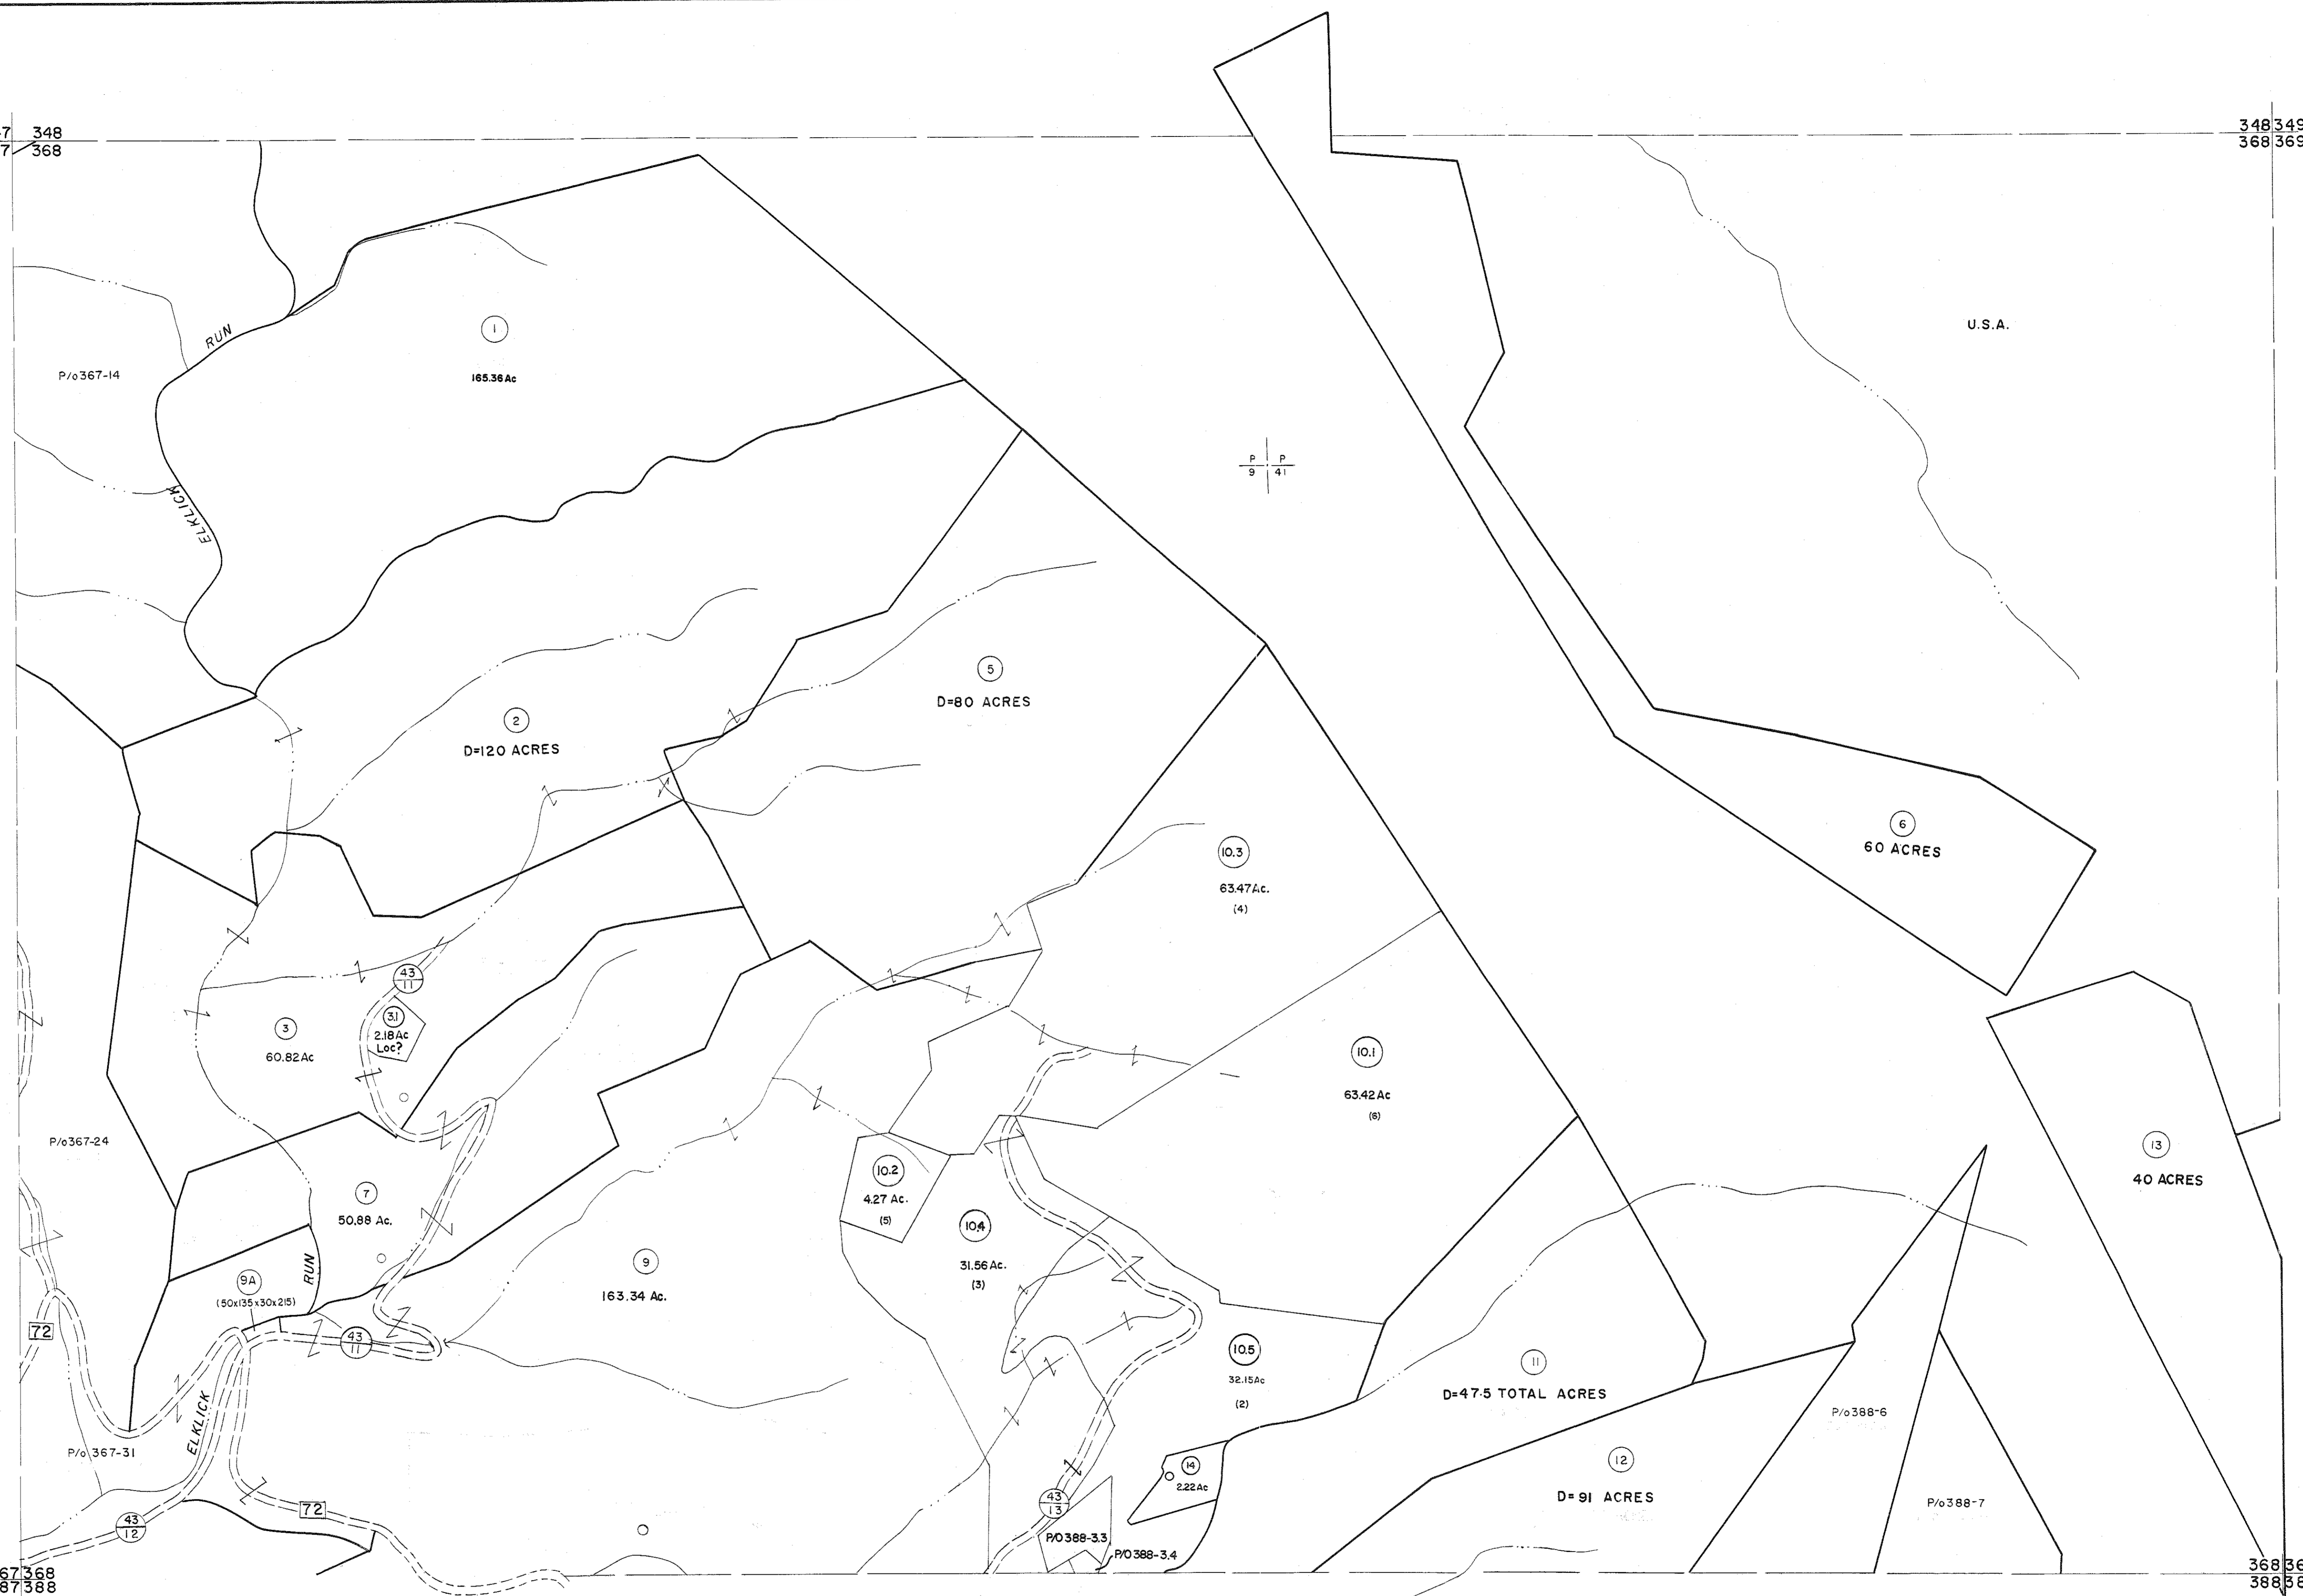

For Tax Purposes Only
 Prepared by
MICHAEL BAKER, JR., INC.
 Consulting Engineers
 Rochester, Pennsylvania

Legend

| | | | |
|-----------------------------|-------|------------------------|-------|
| Property line | ————— | Original lot line | ————— |
| Edge of pavement or roadway | ----- | Deed lot number | (15) |
| Corporation line | ----- | Parcel or index number | (9) |
| District line | ----- | Improvement | o |
| County line | ----- | Railroad | o |

Revisions

| | | | | | | | |
|---|-----------|------------|--------|----------|--------|-----|----|
| 1 | 11/22/78 | OG | 9 | SLS INC. | 3/2/00 | JWM | 17 |
| 2 | 1/22/83 | OG | 10 | 4-22-08 | | HAS | 18 |
| 3 | 1/22/83 | OG | 11 | 6-21-09 | | HAS | 19 |
| 4 | OGIS | 1/6/91 | DSH | 5-4-13 | | HAS | 20 |
| 5 | OGIS | 12/12/93 | SAJ | 5/25/15 | | SBH | 21 |
| 6 | OGIS | 2-95 | HD | | | | 22 |
| 7 | O.G.I.S. | 4-1-96 | J.E.B. | | | | 23 |
| 8 | S.S. INC. | - DDC 5/97 | | | | | 24 |

KEY MAP

 348
 367 368 369
 368

TUCKER COUNTY
 STATE OF WEST VIRGINIA
 Office of Assessor

DISTRICT
DRY FORK
 SHEET NO: 368
 Date, Aerial Photography: November, 1961 Date, Map: Dec., 1962
 Photo No: Scale: 1" = 400'