


389|390
409|410

390|391
410|411

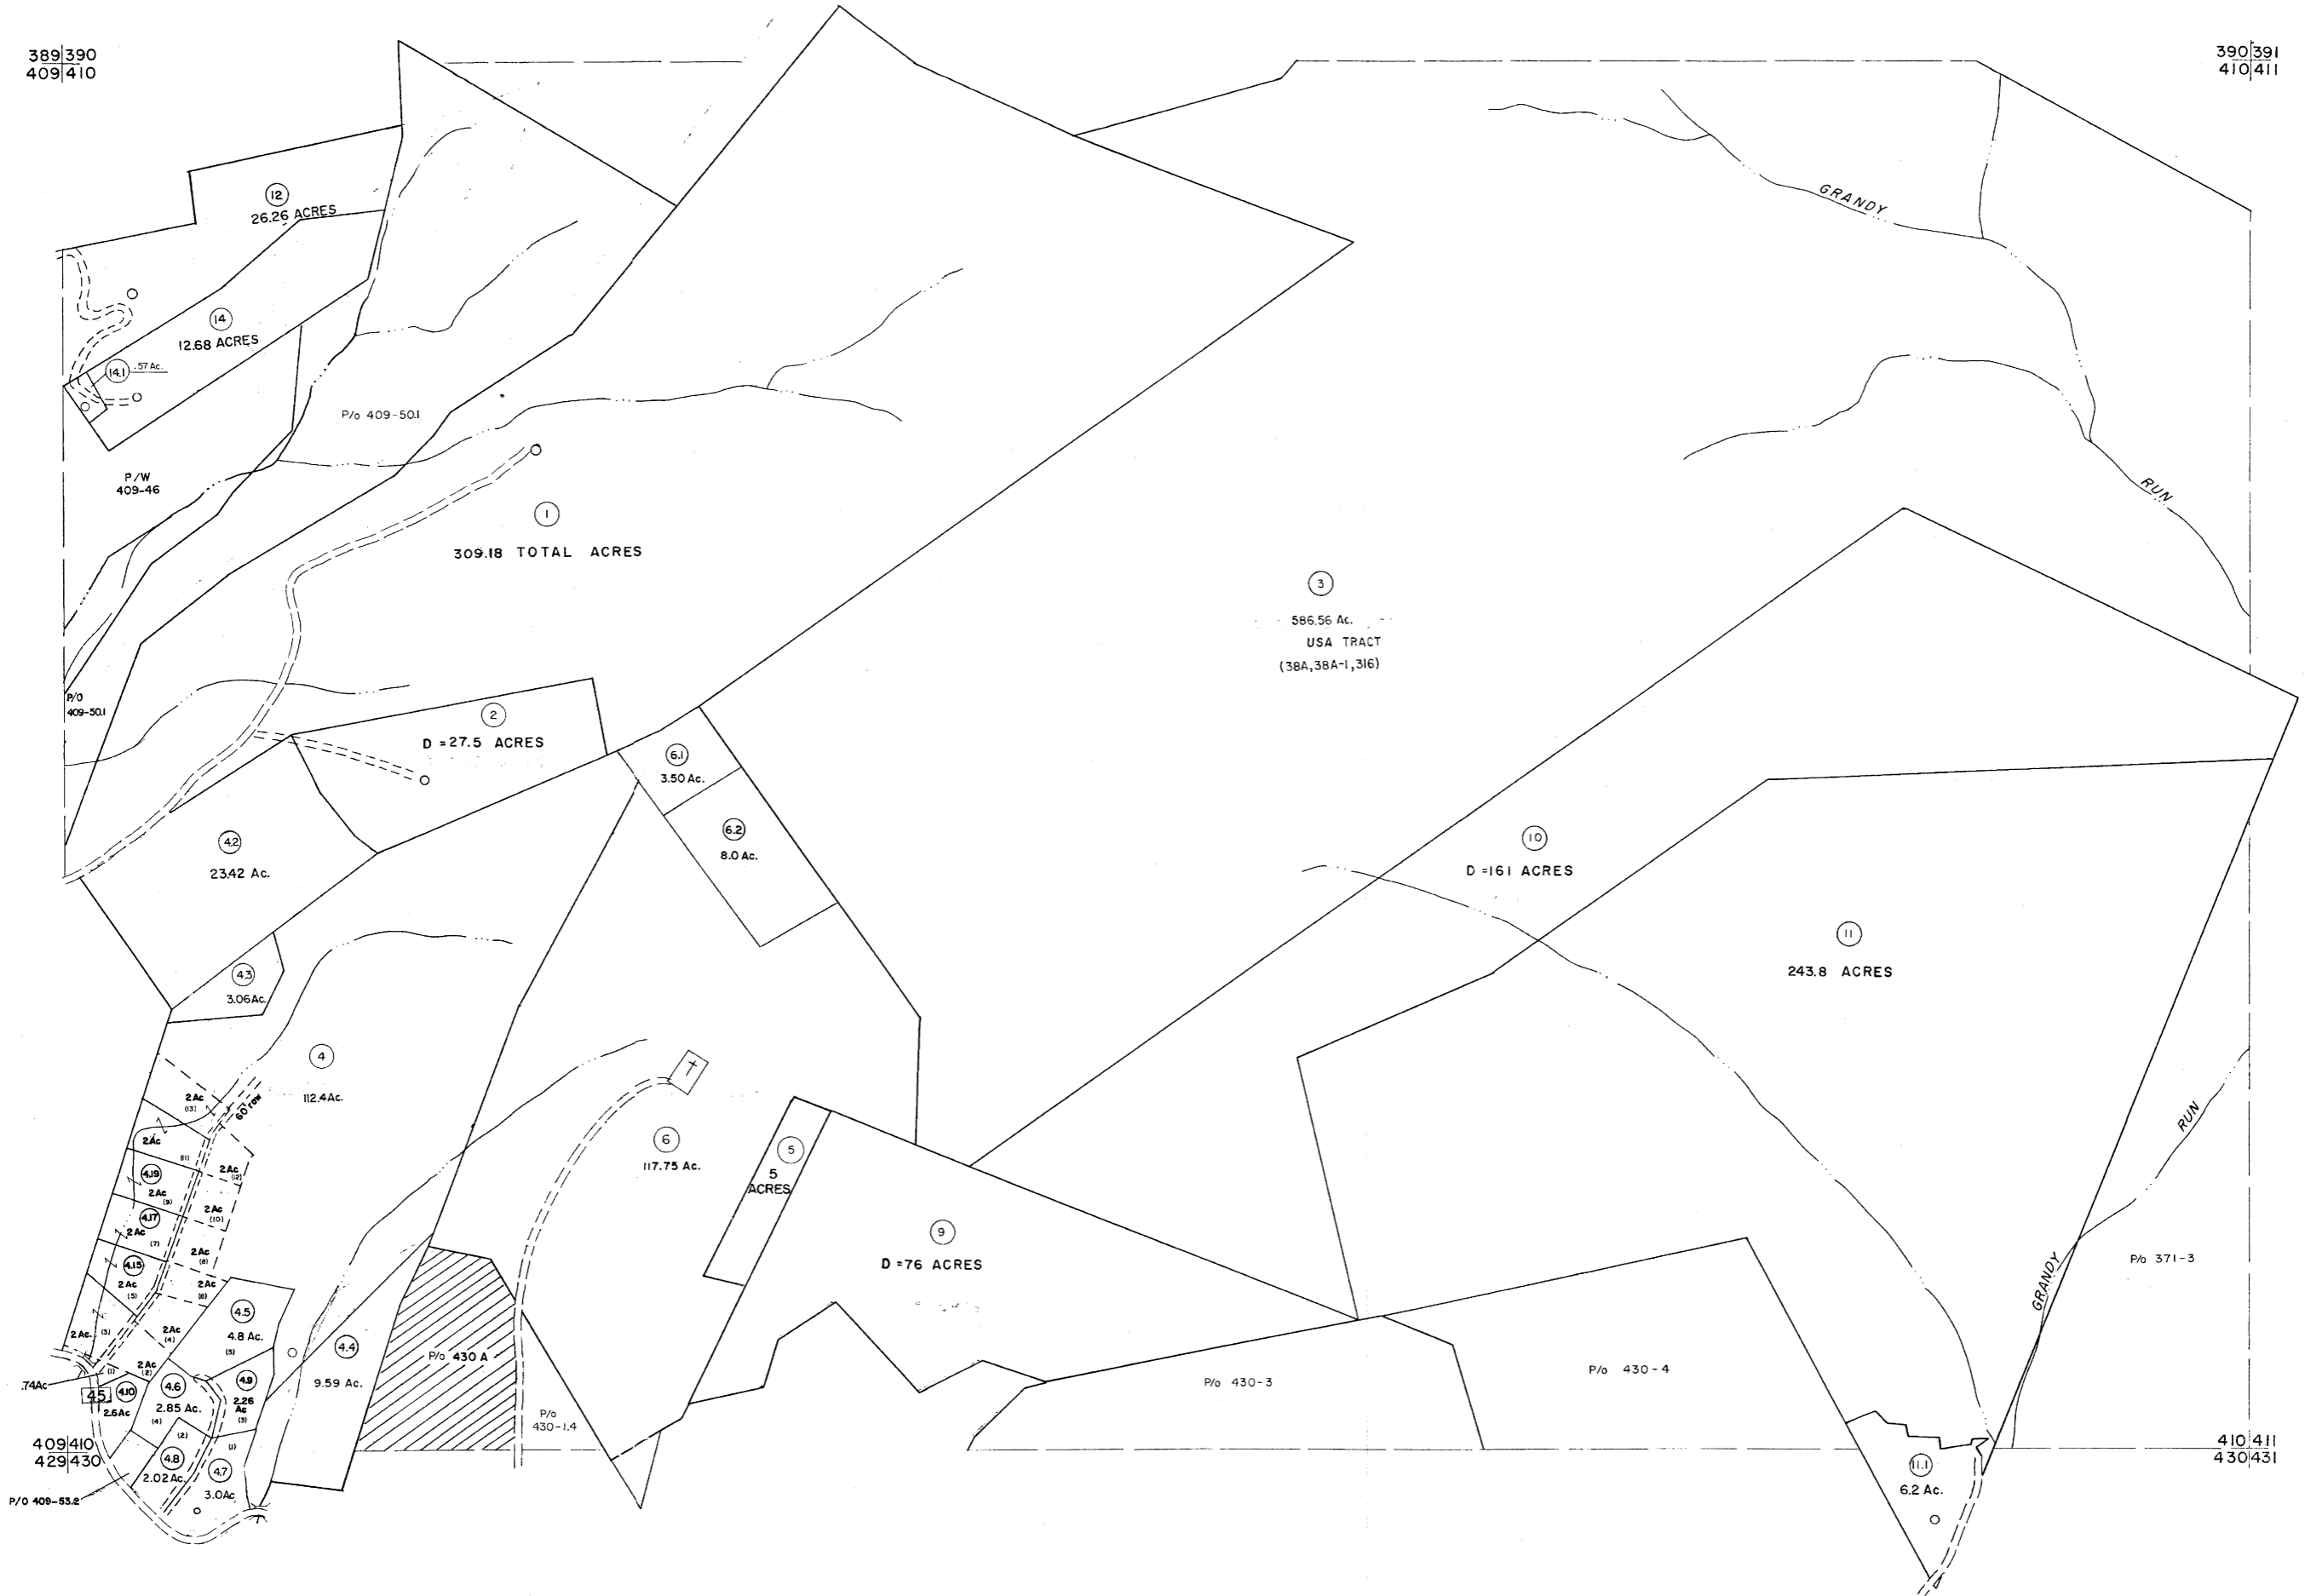

For Tax Purposes Only

Prepared by
MICHAEL BAKER, JR., INC.
Consulting Engineers
Rochester, Pennsylvania

Legend

Property line	---	Original lot line	---
Edge of pavement or roadway	---	Dead lot number	(15)
Corporation line	---	Parcel or index number	(99)
District line	---	Improvement	(15)
County line	---	Railroad	(15)

Revisions

1	11-27-78	DG	9	SLS INC. - DDC	5/97	17	6-22-08	14-4-5
2	REV. TO 7-1-83	NCS	10	SLS INC.	3/4/98	18	6-21-09	11-4-5
3	7-1-84	L.E.S.	11	SLS INC.	1/28/99	19		
4	REV. TO 7-1-85	NCS	12	ESI	2/12/02	20		
5	REV. TO 3-1-89	R.E.B.	13	ESI	2/20/03	21		
6	OGIS 2/1/93	DSH	14	HBS	2/04	22		
7	OGIS 12/12/93	SAJ	15		3/21/05	23		
8	O.G.I.S 4-1-96	J.E.B.	16		3/18/06	24		

KEY MAP



TUCKER COUNTY
STATE OF WEST VIRGINIA
Office of Assessor

DISTRICT

DRY FORK

SHEET NO: 410

Date, Aerial Photography: Nov, 1961 Date, Map: Dec, 1962
Photo No: Scale: 1" = 400'