


124 | 125

125

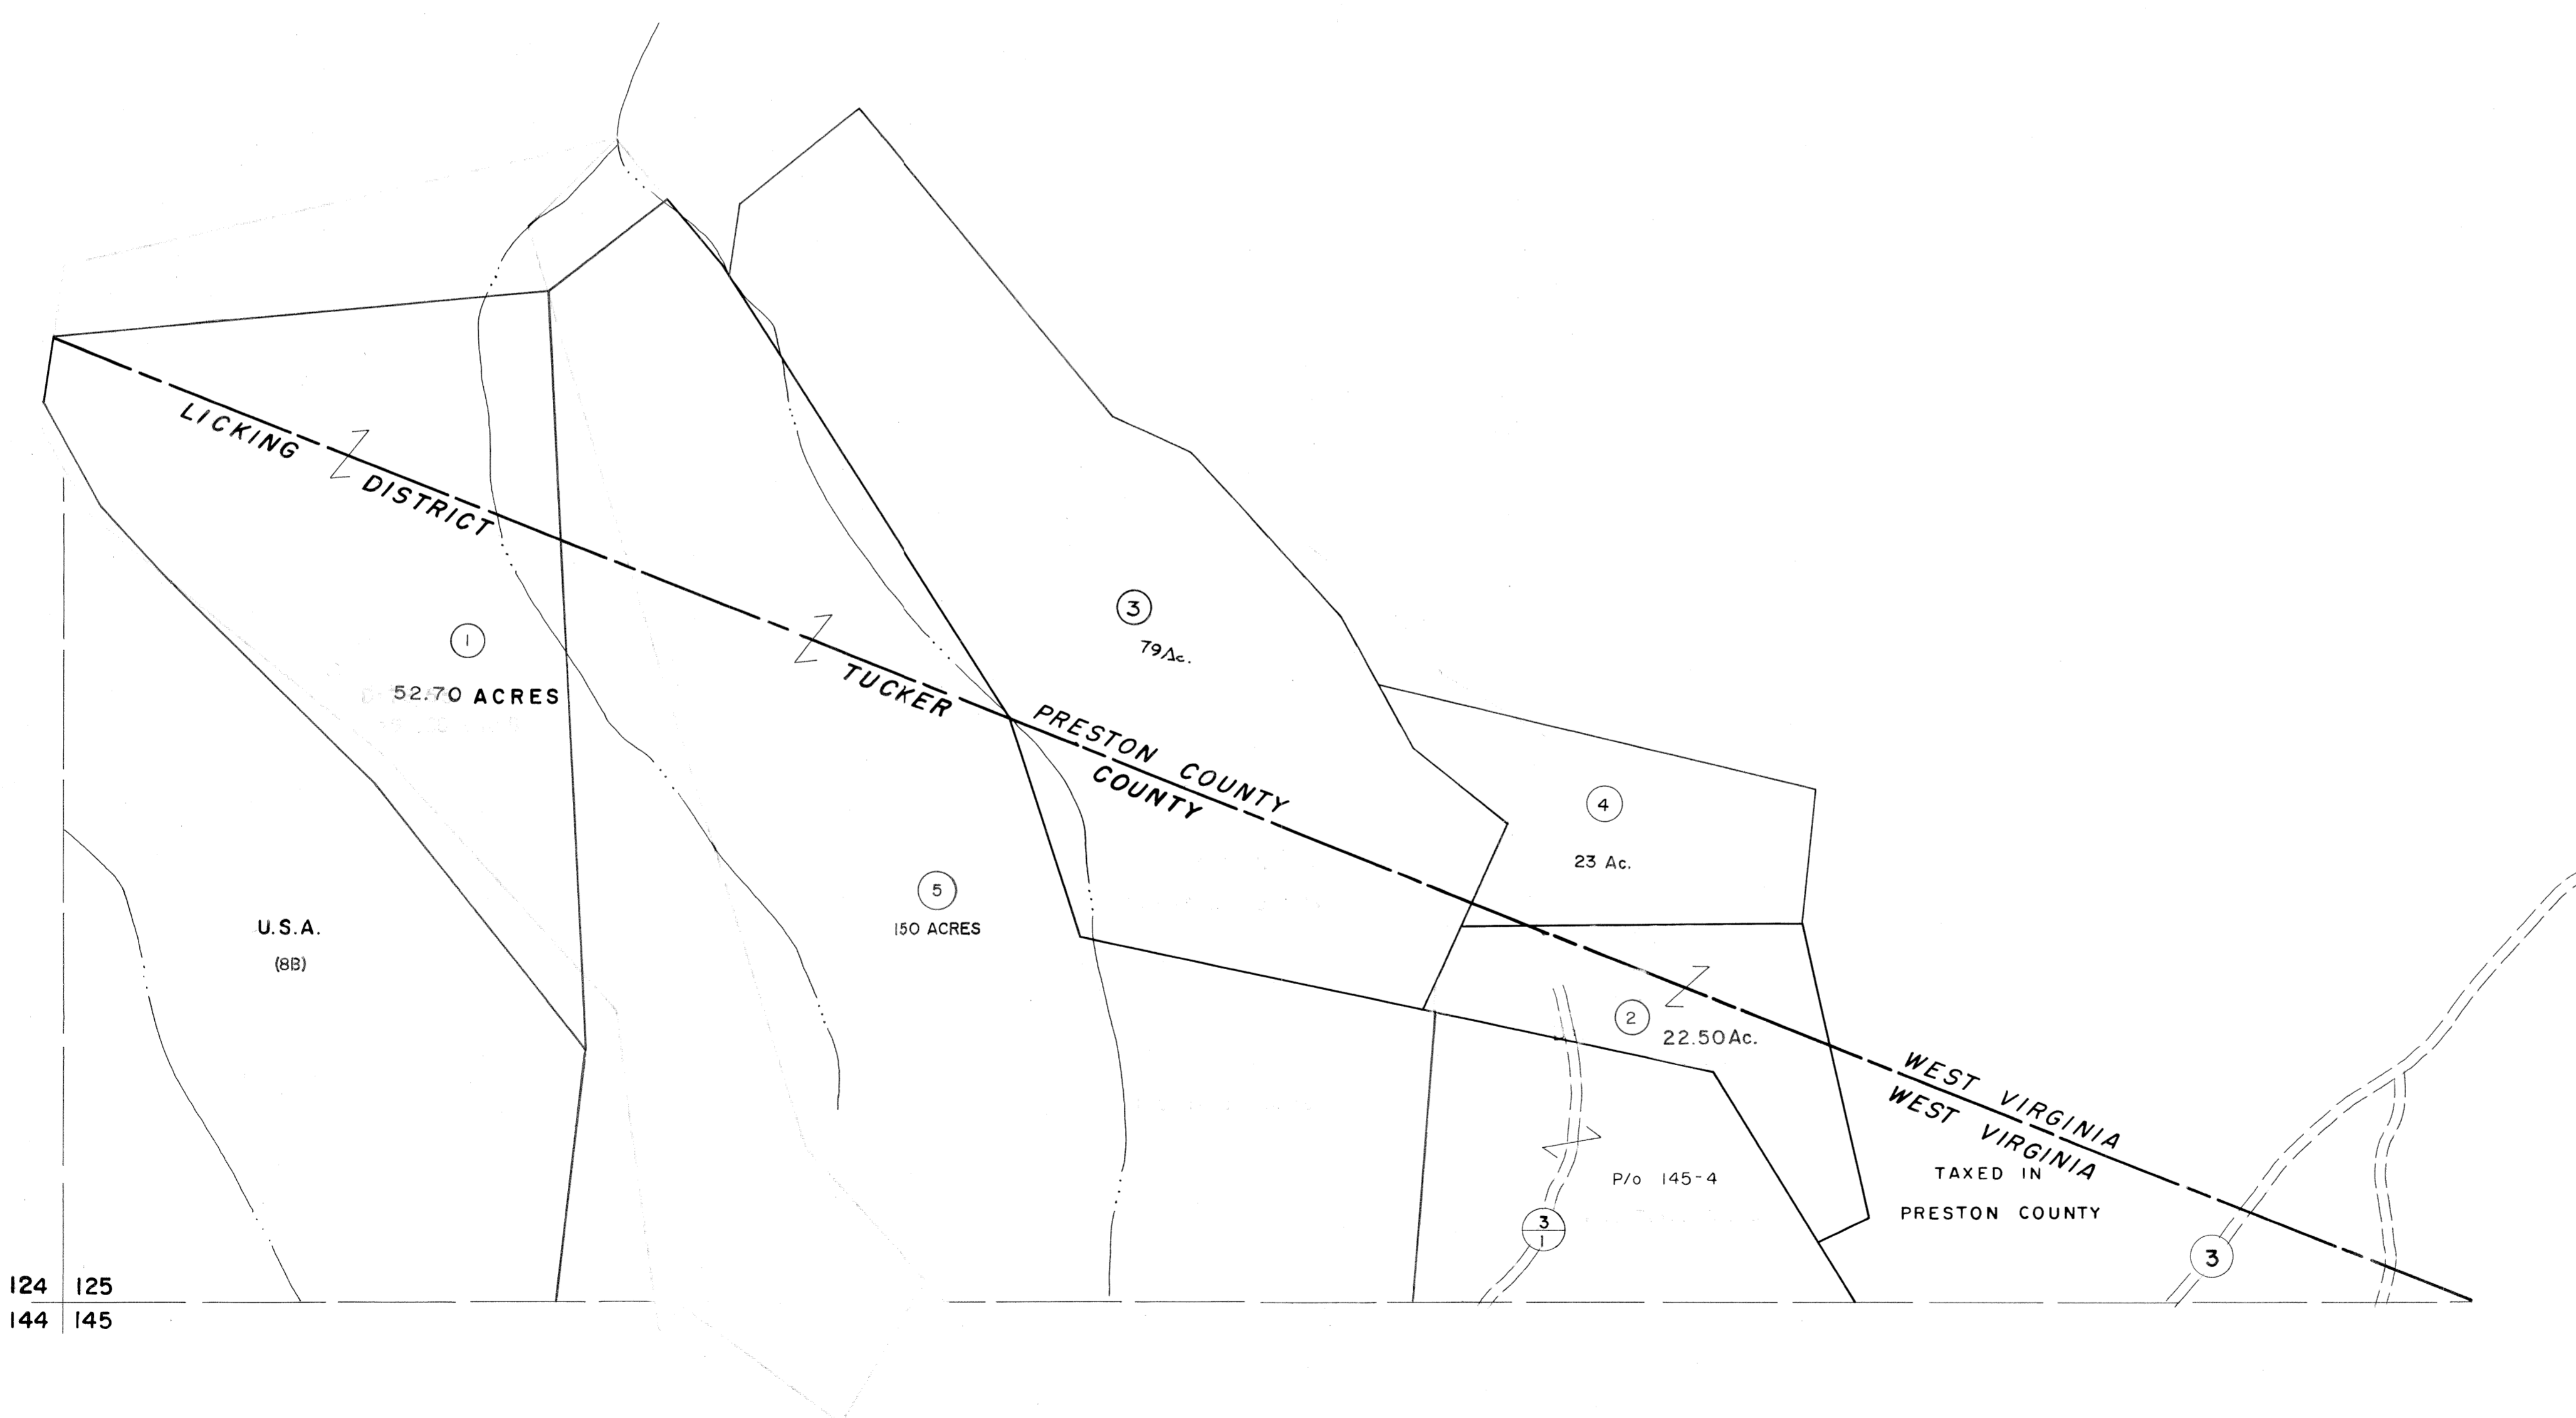

124 | 125
144 | 145

125 | 146
145 | 146

For Tax Purposes Only

Prepared by
MICHAEL BAKER, JR., INC.
Consulting Engineers
Rochester, Pennsylvania


Legend

Property line	—————	Original lot line	-----
Edge of pavement or roadway	-----	Deed lot number	(15)
Corporation line	-----	Parcel or index number	(29)
District line	-----	Improvement	o
County line	-----	Railroad	+

Revisions

1	11/16/78	DG	9	SLS INC. - DDC 5/97	17
2	Revised to 7-1-88	L.E.S.	10	5-8-10	18
3	7-1-84	L.E.S.	11		19
4	Revised to 7-1-87		12		20
5	OGIS 12/29/90	DSH	13		21
6	OGIS 1/23/93	DSH	14		22
7	OGIS 12/9/93	SAJ	15		23
8			16		24

KEY MAP

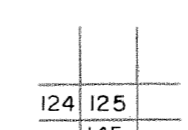

TUCKER COUNTY
STATE OF WEST VIRGINIA
Office of Assessor

DISTRICT

LICKING

SHEET NO: 125

Date, Aerial Photography: November, 1961 Date, Map: Dec, 1962
Photo No: Scale: 1" = 400'