


124 125

125

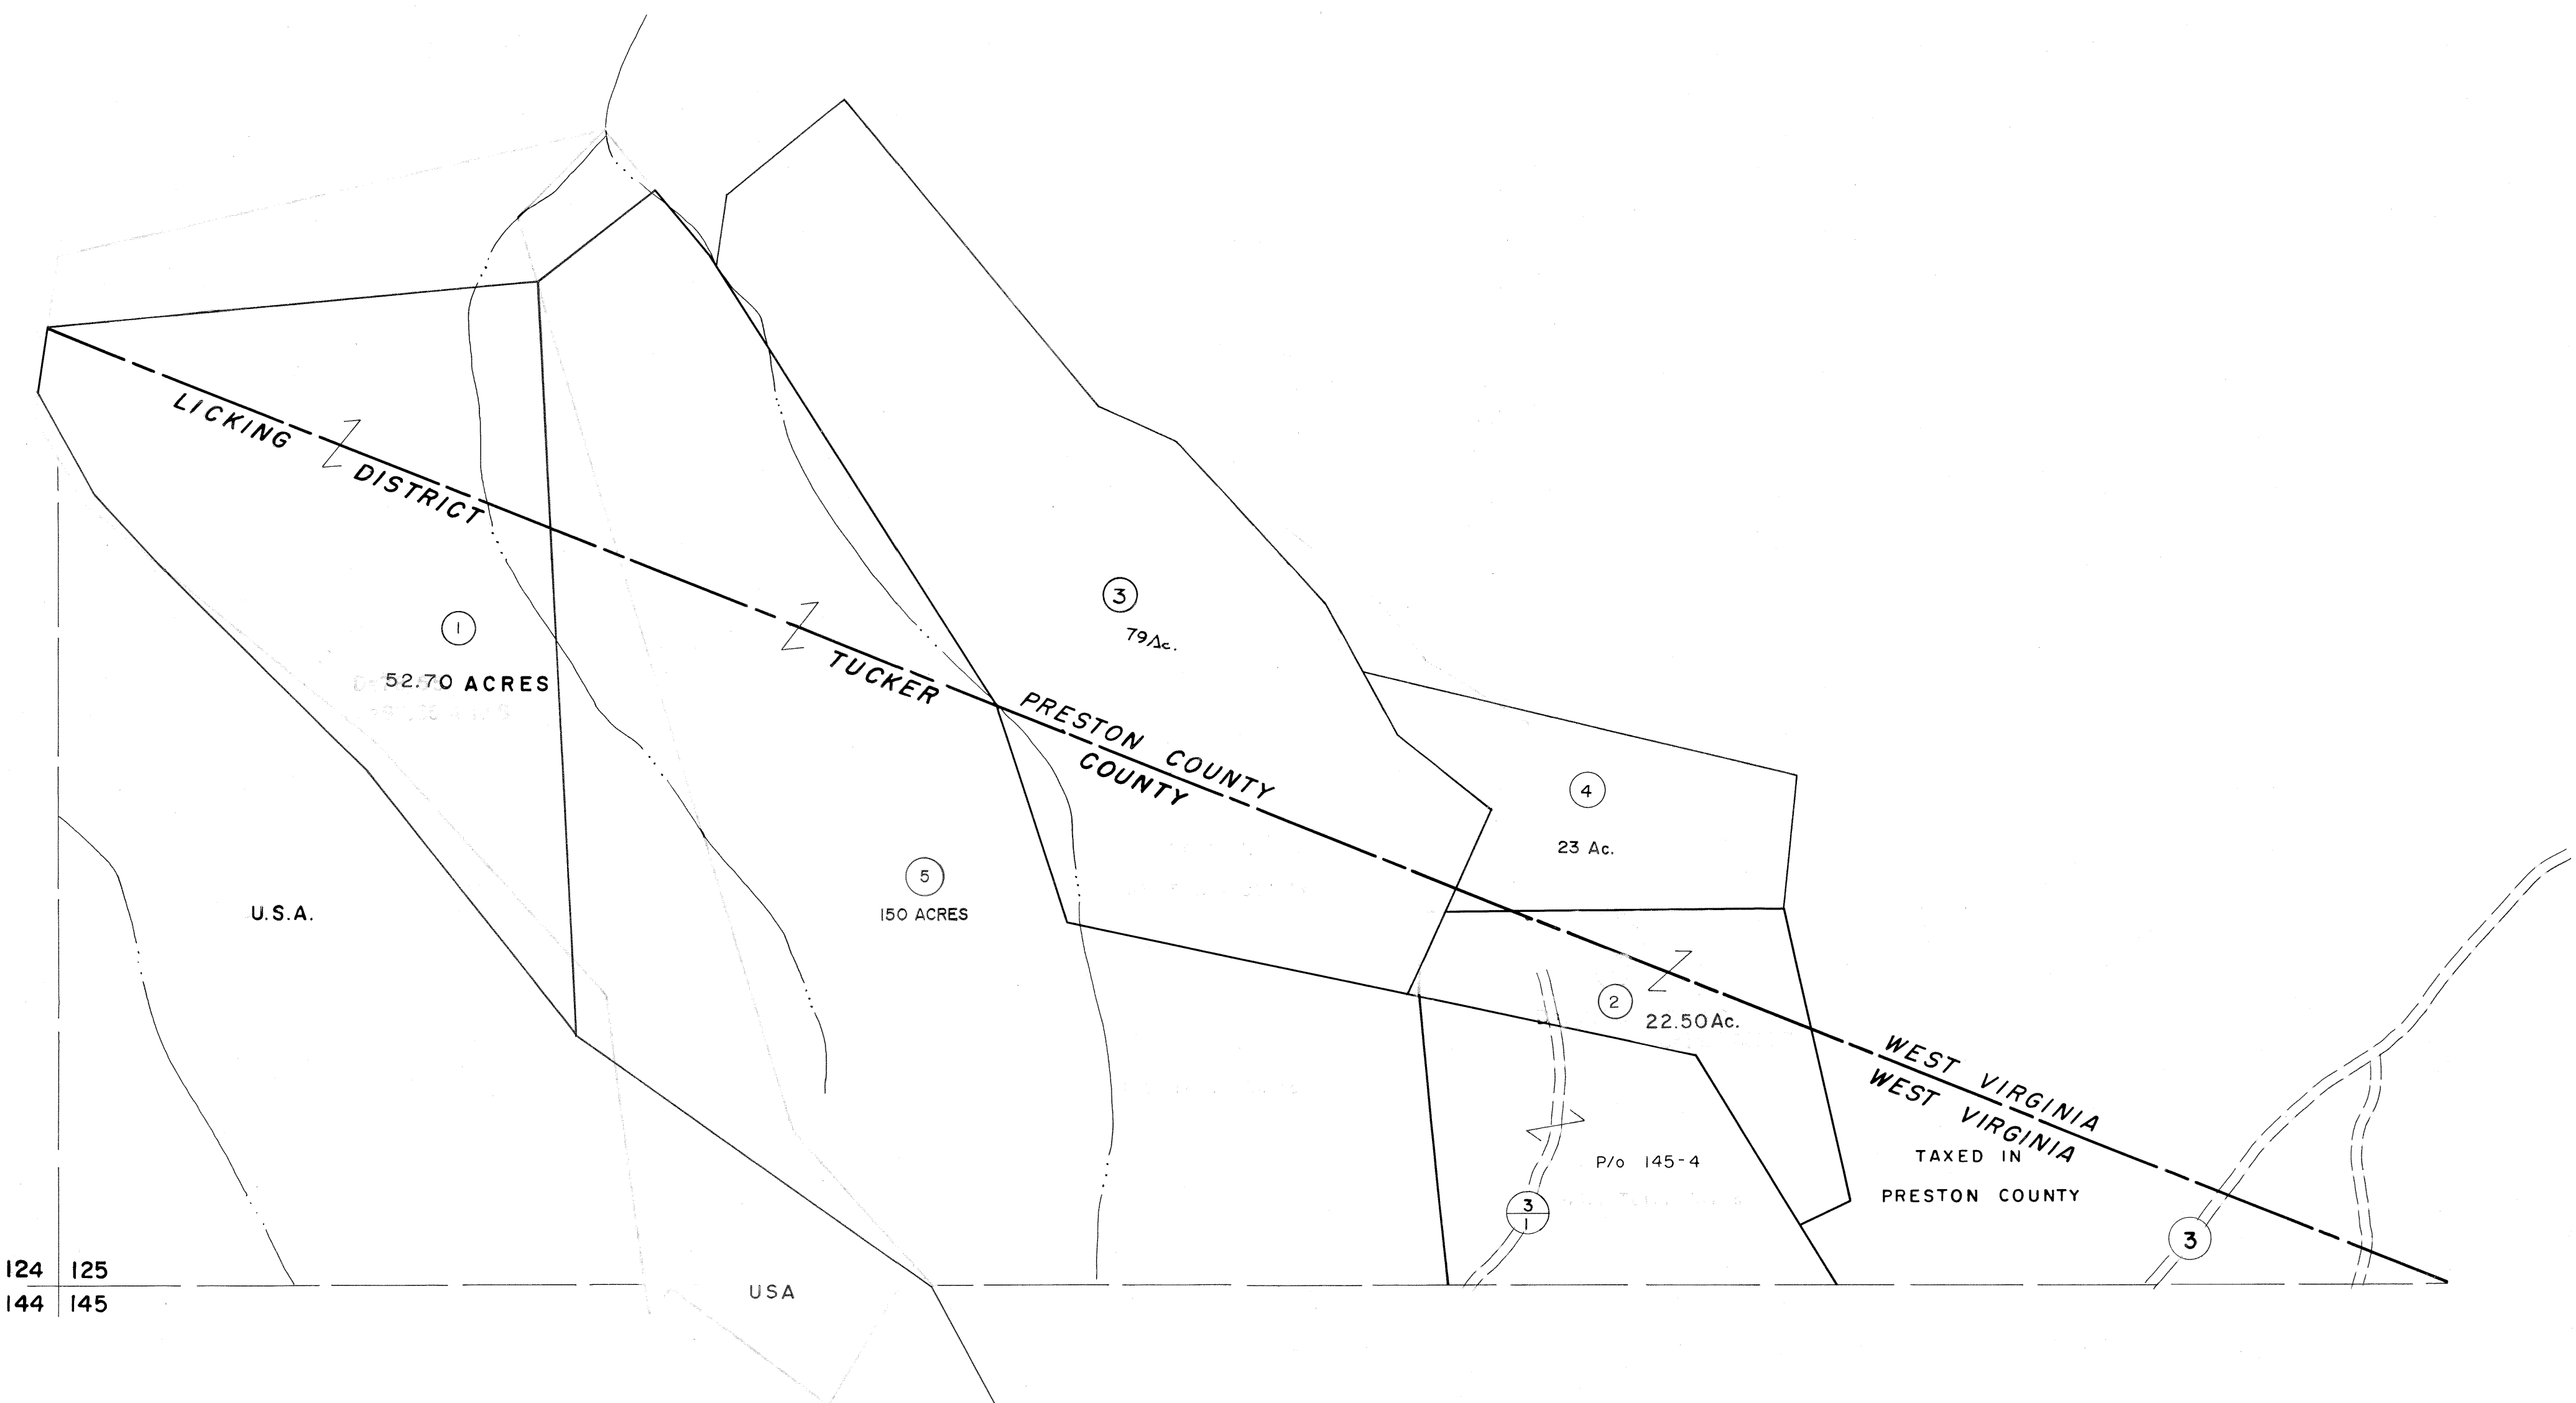

124 125  
144 145

125  
145 146

For Tax Purposes Only

Prepared by  
MICHAEL BAKER, JR., INC.  
Consulting Engineers  
Rochester, Pennsylvania

Legend

Property line	-----	Original lot line	-----
Edge of pavement or roadway	-----	Dead lot number	(15)
Corporation line	-----	Parcel or index number	(99)
District line	-----	Improvement	o
County line	-----	Railroad	+

Revisions

1	11/14/78	DG	SLS INC. - DDC 5/97	17
2	Revised to 7-1-83	L.E.S.		18
3	7-1-84	L.E.S.		19
4	Revised to 7-1-87	L.E.S.		20
5	OGIS 12/29/90	DSH		21
6	OGIS 1/23/93	DSH		22
7	OGIS 12/9/93	SAJ		23
8				24

KEY MAP



TUCKER COUNTY

STATE OF WEST VIRGINIA

Office of Assessor

DISTRICT

LICKING

SHEET NO: 125

Date, Aerial Photography: November, 1961 Date, Map: Dec, 1962  
Photo No: Scale: 1" = 400'