


160
180

160 161
180 181

180
200

180 181
200 201

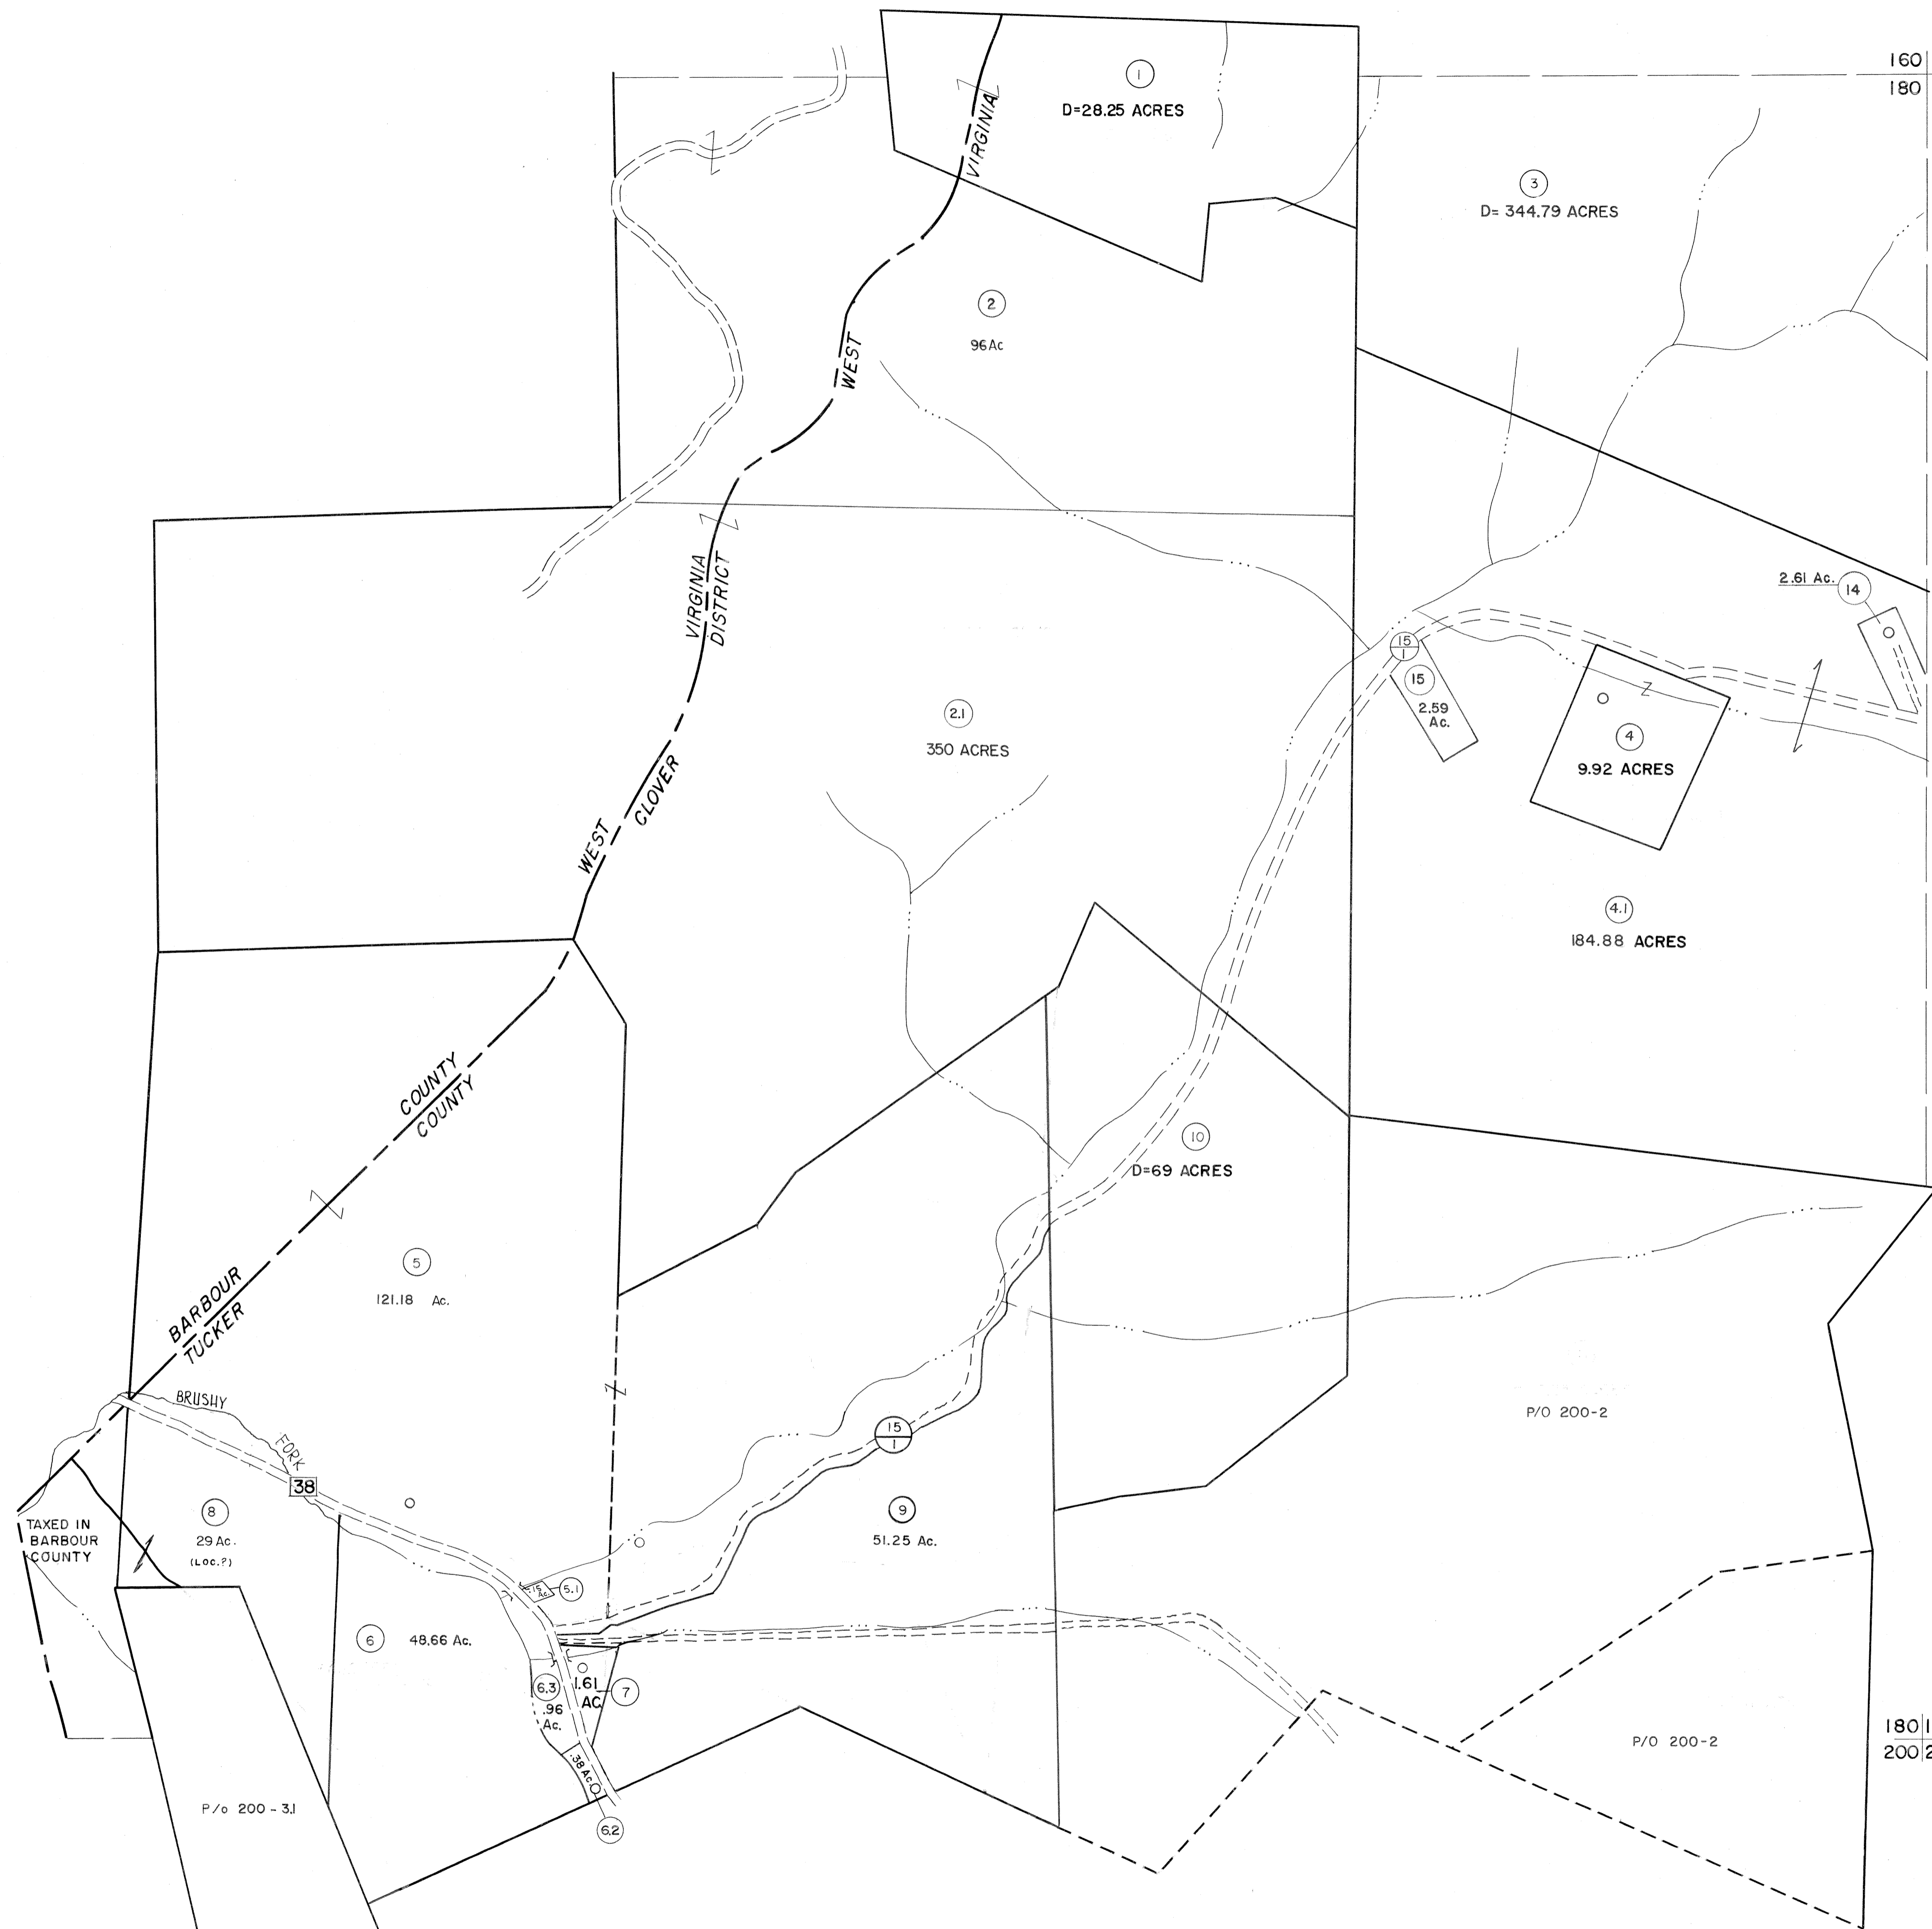

For Tax Purposes Only

Prepared by
MICHAEL BAKER, JR., INC.
Consulting Engineers
Rochester, Pennsylvania


Legend

| | | | |
|-----------------------------|-------|------------------------|-------|
| Property line | ————— | Original lot line | ----- |
| Edge of pavement or roadway | ----- | Deed lot number | (15) |
| Corporation line | ----- | Parcel or index number | (29) |
| District line | ----- | Improvement | o |
| County line | ----- | Railroad | + |

Revisions

| | | | | | | | | | |
|---|-------------------|----------|-----|----------|----------|---------|----|---------|-----|
| 1 | 6-6-75 | SC | 9 | OGIS | 1/24/93 | DSH | 17 | 3/26/07 | SBH |
| 2 | 11/17/78 | DG | 10 | OGIS | 12/11/93 | SAJ | 18 | | |
| 3 | REVISED TO 7-1-83 | | 11 | SLS INC. | - DDC | 5/97 | 19 | | |
| 4 | 7-1-84 | L.E.S. | 12 | SLS INC. | 1/27/99 | DSW | 20 | | |
| 5 | REV TO 7-1-86 | NCS | 13 | ESI | 1/31/01 | REK | 21 | | |
| 6 | REV TO 3-1-89 | NCS | 14 | ESI | 2/20/03 | REK | 22 | | |
| 7 | OGIS | 12/30/90 | DSH | 15 | HBS | 2/22/04 | 23 | | |
| 8 | | | 16 | | | | 24 | | |

KEY MAP

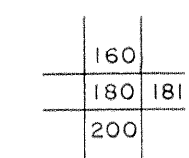

TUCKER COUNTY
STATE OF WEST VIRGINIA
Office of Assessor

DISTRICT

CLOVER

SHEET NO: 180

Date, Aerial Photography: November, 1961 Date, Map: Dec., 1961
Photo No: Scale: 1" = 400'