


180  
200

180 181  
200 201

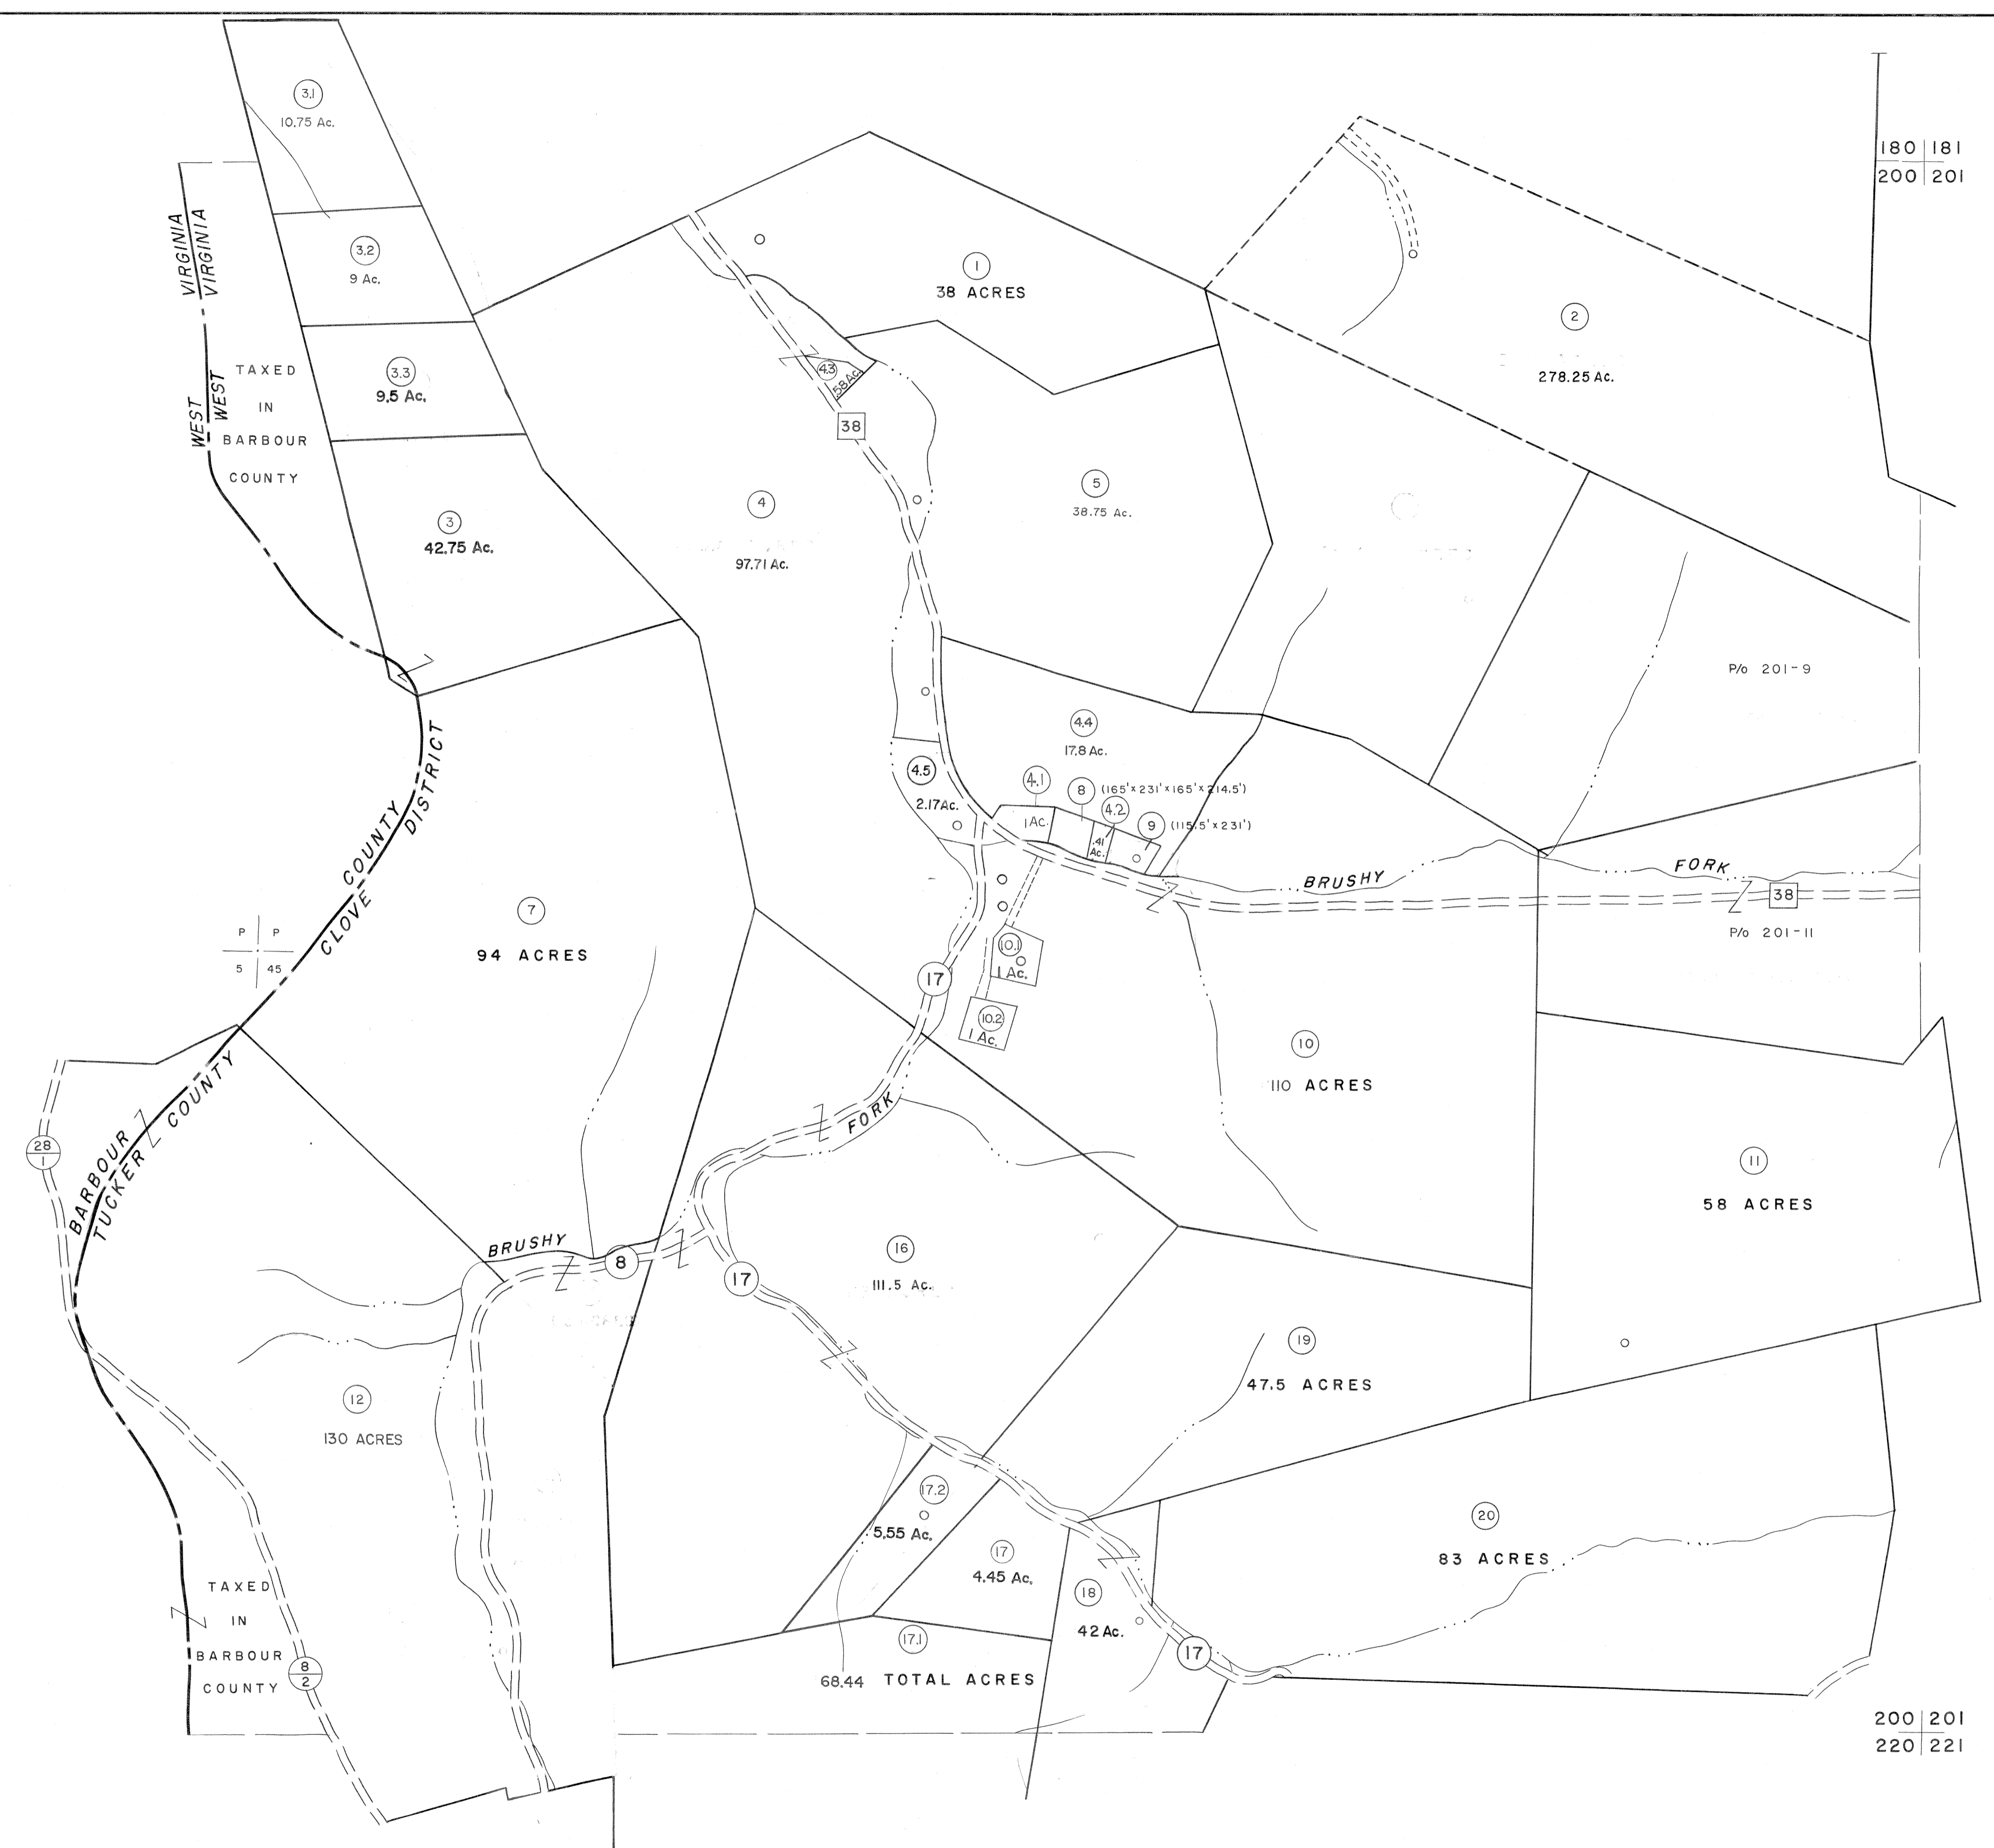

200  
220

200 201  
220 221

For Tax Purposes Only

Prepared by  
MICHAEL BAKER, JR., INC.  
Consulting Engineers  
Rochester, Pennsylvania

Legend	
Property line	Original lot line
Edge of pavement or roadway	Deed lot number
Corporation line	Parcel or index number
District line	Improvement
County line	Railroad

Revisions			
1	6-3-64	9	SLS INC. - DDC 5/97
2	6-3-75	10	SLS INC. 2/19/98 DSW
3	12/1/83	11	SLS INC. 1/27/99 DSW
4	12/1/85	12	ESI 2/7/02 REK
5	OGIS 12/30/90 DSH	13	H&S 2/22/04
6	OGIS 3-19-92 TL	14	3/21/05 S&H
7	OGIS 2-95 HD	15	
8	O.G.I.S 4-1-96 J.E.B	16	

KEY MAP

180  
200 201  
220

**TUCKER COUNTY**  
STATE OF WEST VIRGINIA  
Office of Assessor

DISTRICT  
**CLOVER**

SHEET NO: 200

Date, Aerial Photography: Nov, 1961 Date, Map: Dec, 1962  
Photo No: Scale: 1"=400'