


201 202
221 222

202 203
222 223

221 222
241 242

222 223
242 243

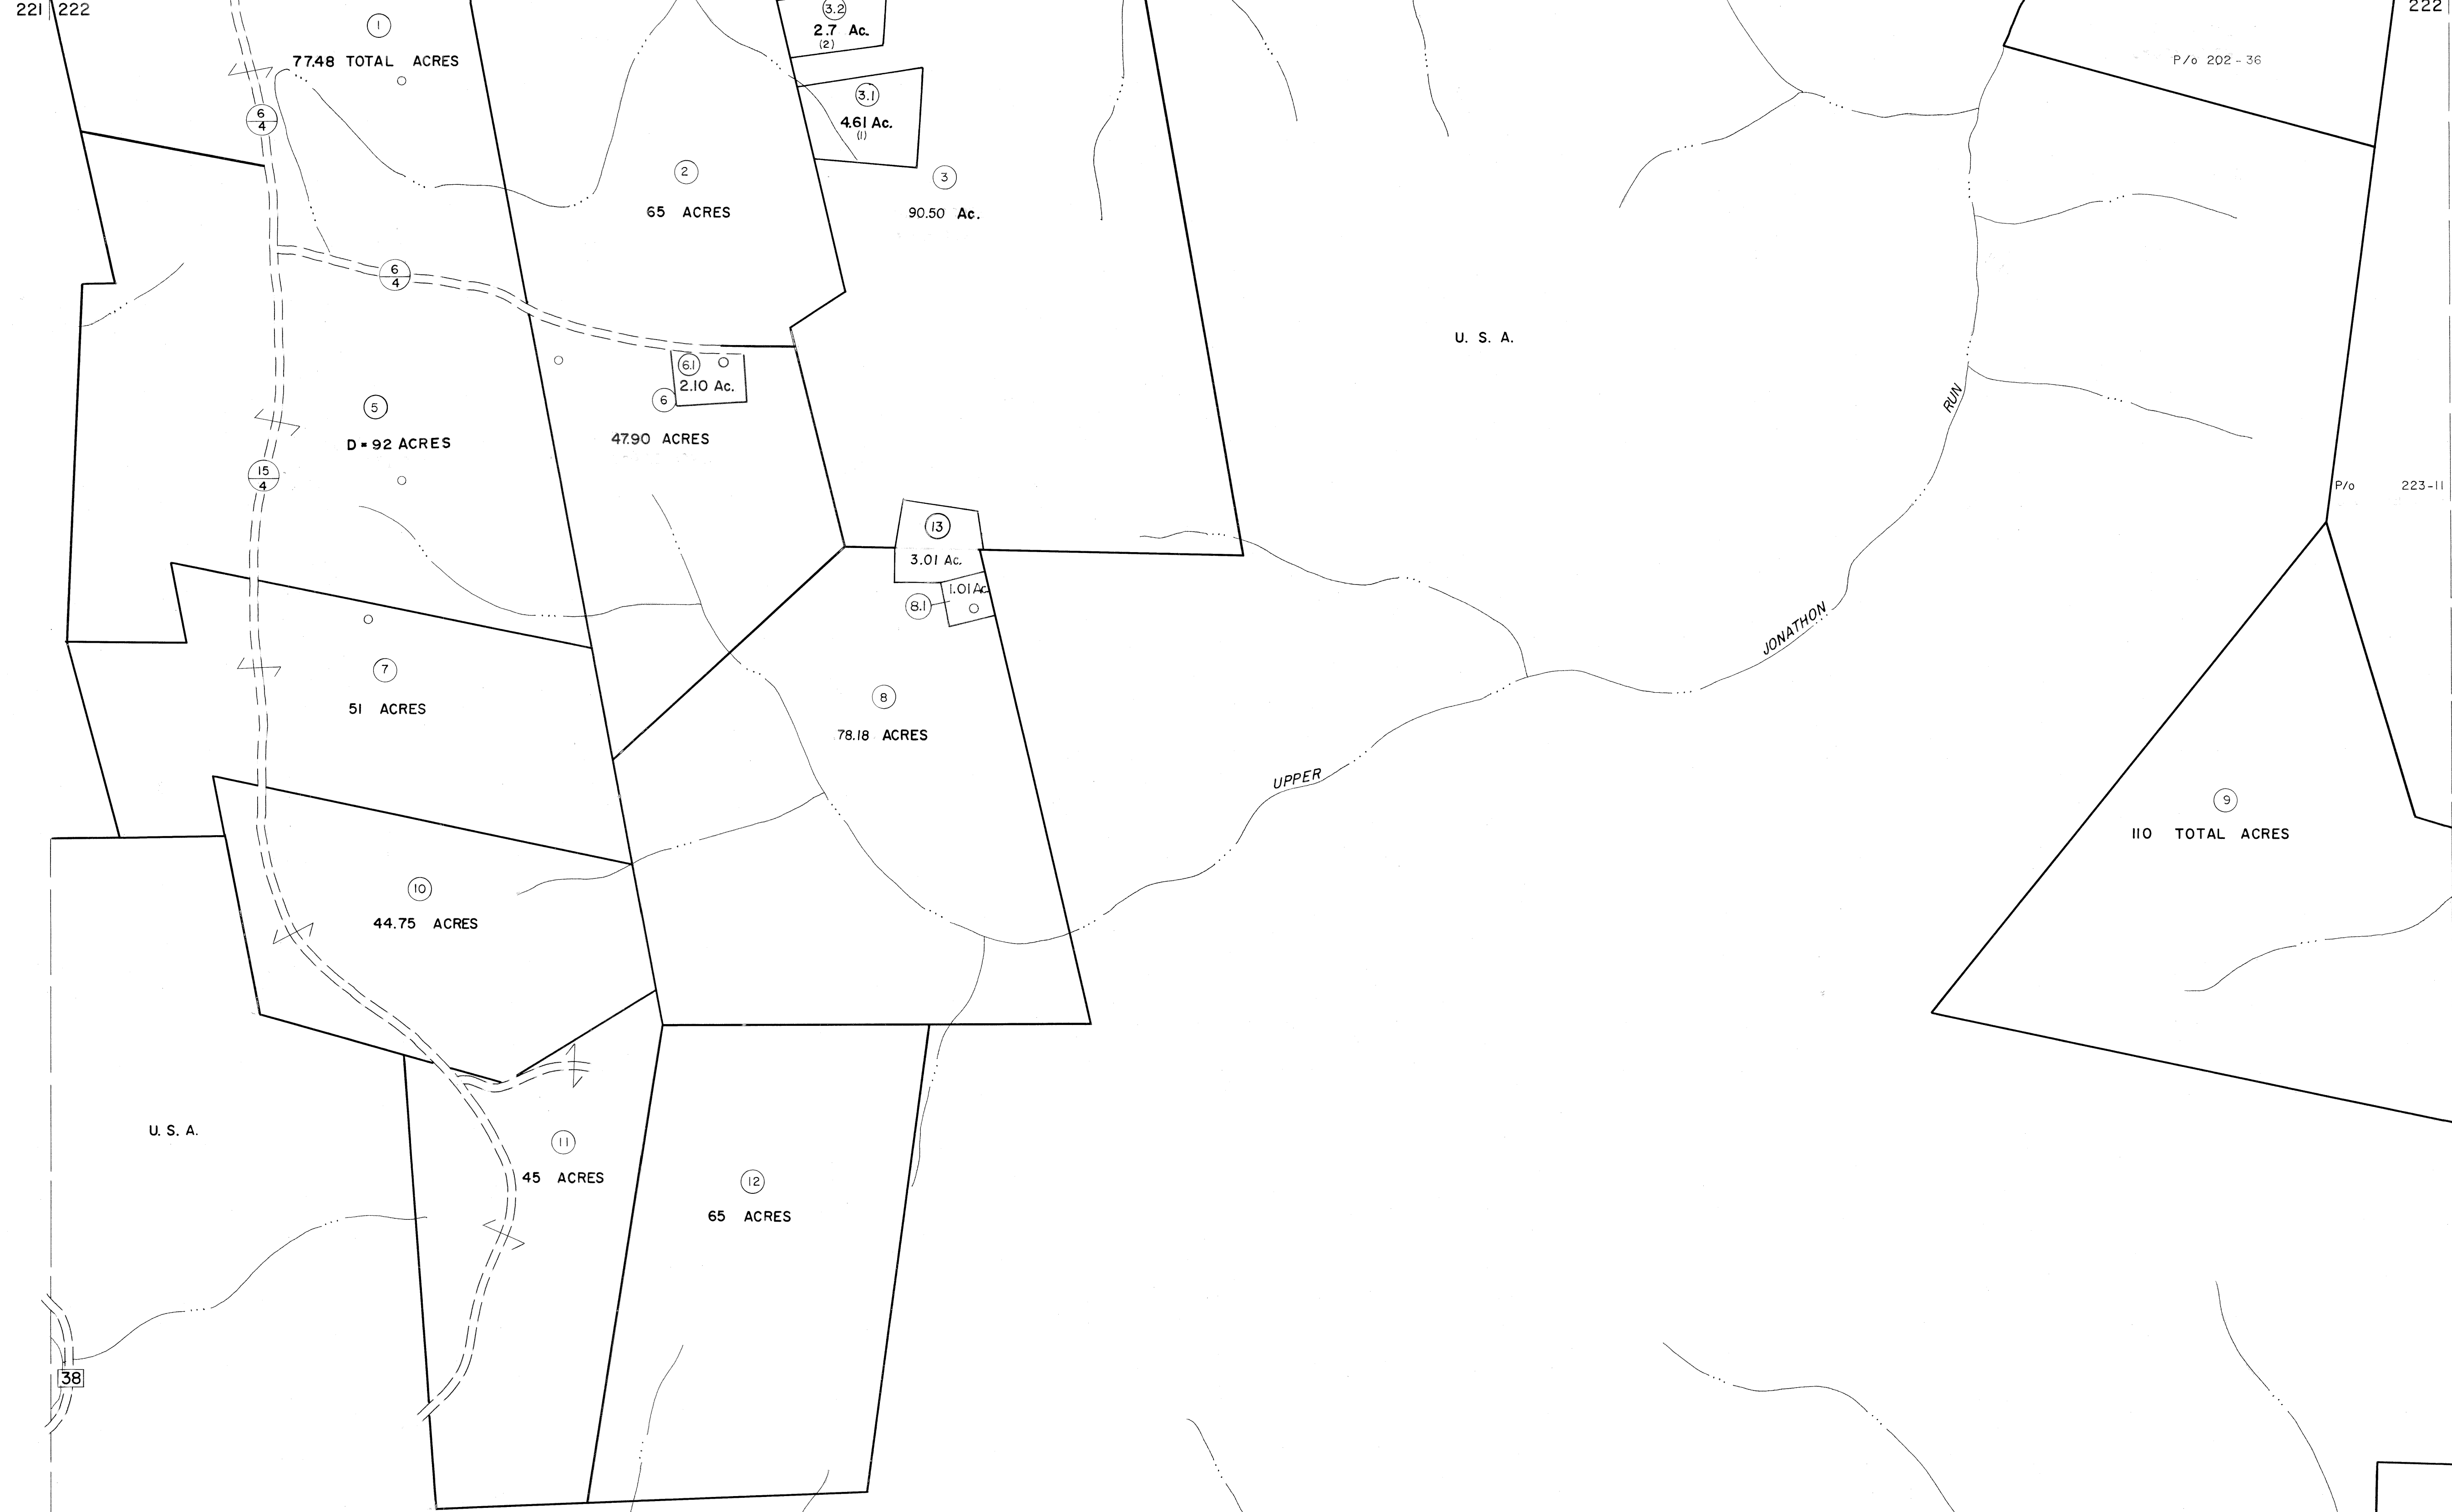


For Tax Purposes Only

Prepared by
MICHAEL BAKER, JR., INC.
Consulting Engineers
Rochester, Pennsylvania

Legend	
Property line	Original lot line
Edge of pavement or roadway	Deed lot number
Corporation line	Parcel or index number
District line	Improvement
County line	Railroad

Revisions			
1	July 1978	RS	9
2	7-1-84	L.E.S.	10
3	REV. TO 3-1-89	R.E.B.	11
4	OGIS 1/25/93	DSH	12
5	OGIS 12/11/93	SAJ	13
6	OGIS 2-95	HD	14
7	SLS INC. - DDC	5/97	15
8			16

KEY MAP

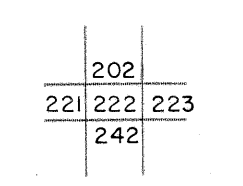

TUCKER COUNTY
STATE OF WEST VIRGINIA
Office of Assessor

DISTRICT	CLOVER
SHEET NO:	222
Date, Aerial Photography:	November, 1961
Date, Map:	Dec, 1962
Photo No:	
Scale:	1" = 400'