


244 245
264 265

245 246
265 266

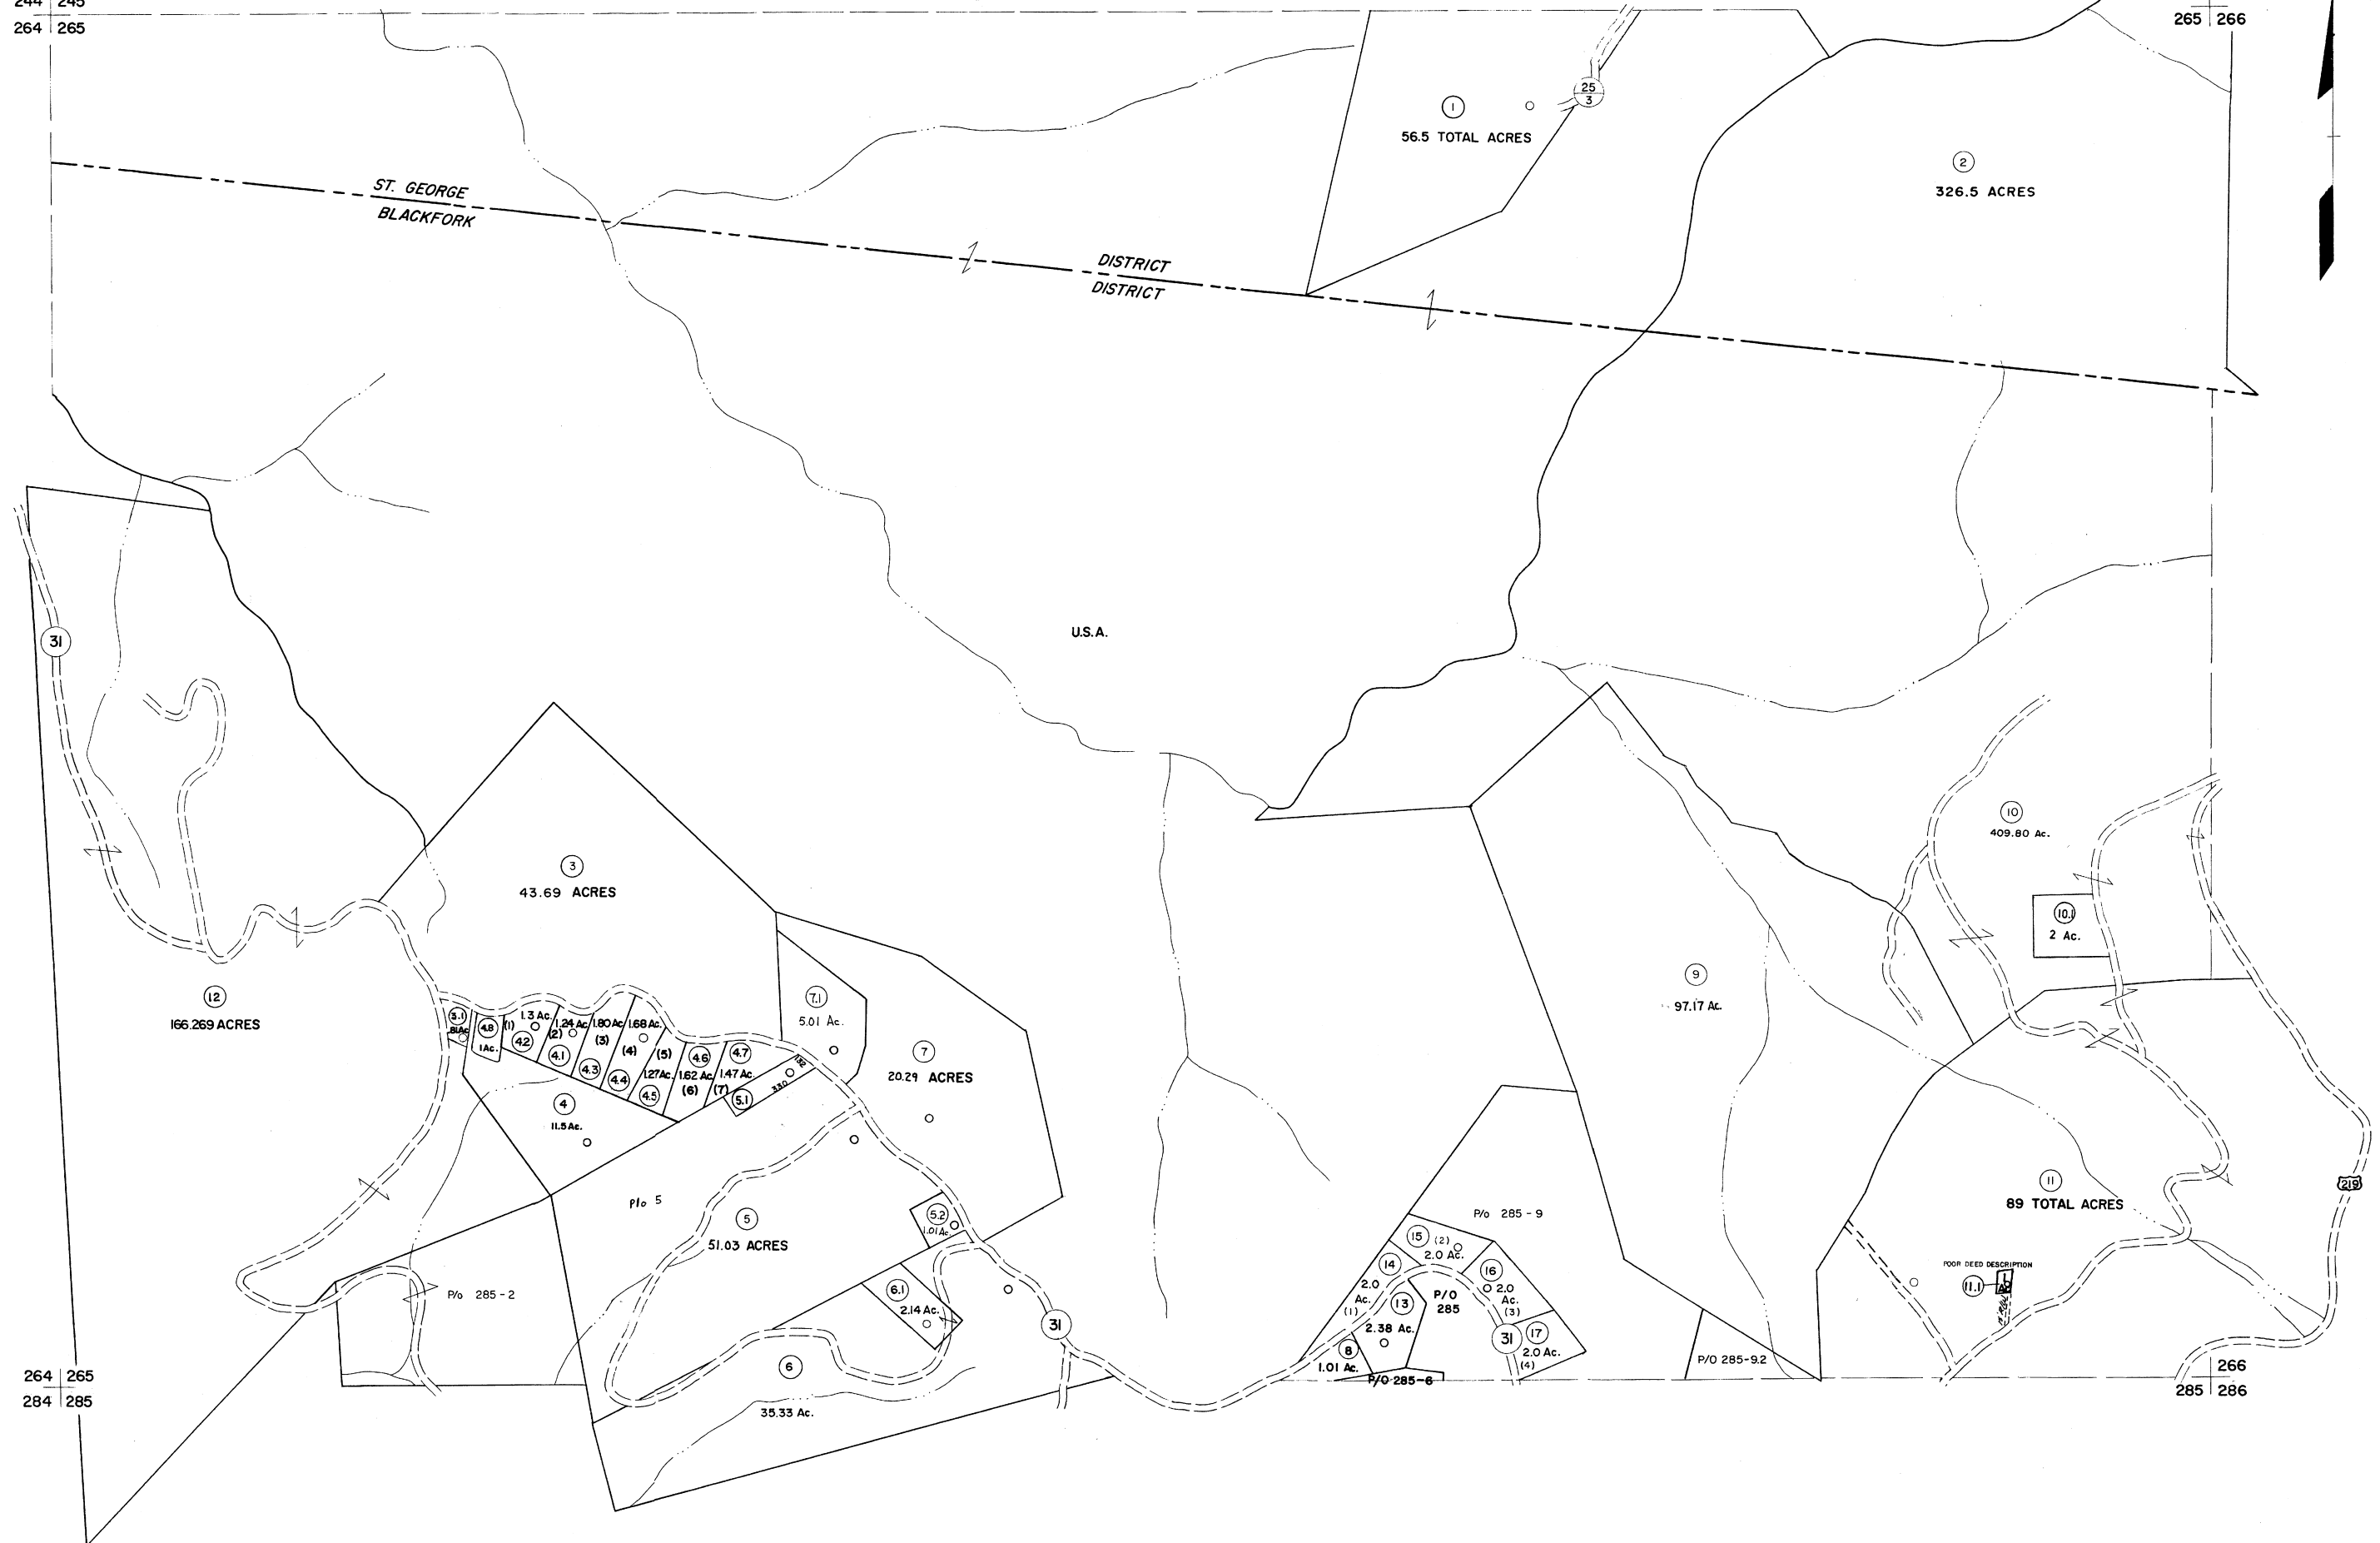

264 265
284 285

266
285 286

For Tax Purposes Only

Prepared by
MICHAEL BAKER, JR., INC.
Consulting Engineers
Rochester, Pennsylvania

Legend	
Property line	—————
Edge of pavement or roadway	—————
Corporation line	—————
District line	—————
County line	—————
Original lot line	—————
Deed lot number	(15)
Parcel or index number	(99)
Improvement	o
Railroad	—————

Revisions	
1	6-4-75 T.G.
2	11-27-78 T.G.
3	Revised 7-1-83
4	OGIS 1/1/91 DSH
5	OGIS 3-19-92 TL
6	OGIS 12/12/93 SAJ
7	O.G.I.S 4-1-96 J.E.B.
8	SLS INC. - DDC 5/97
9	SLS INC. 1/27/99 DSW
10	ESI 1/31/01 REK
11	HBS 2/19/04
12	6-22-08 H.S.
13	6-21-09 H.S.
14	
15	
16	
17	
18	
19	
20	
21	
22	
23	
24	

KEY MAP

TUCKER COUNTY
STATE OF WEST VIRGINIA
Office of Assessor

DISTRICT BLACKFORK ST. GEORGE

SHEET NO: 265

Date, Aerial Photography: November, 1961 Date, Map: Dec, 1962
Photo No: Scale: 1" = 400'