


322 323
342 343

323 324
343 344

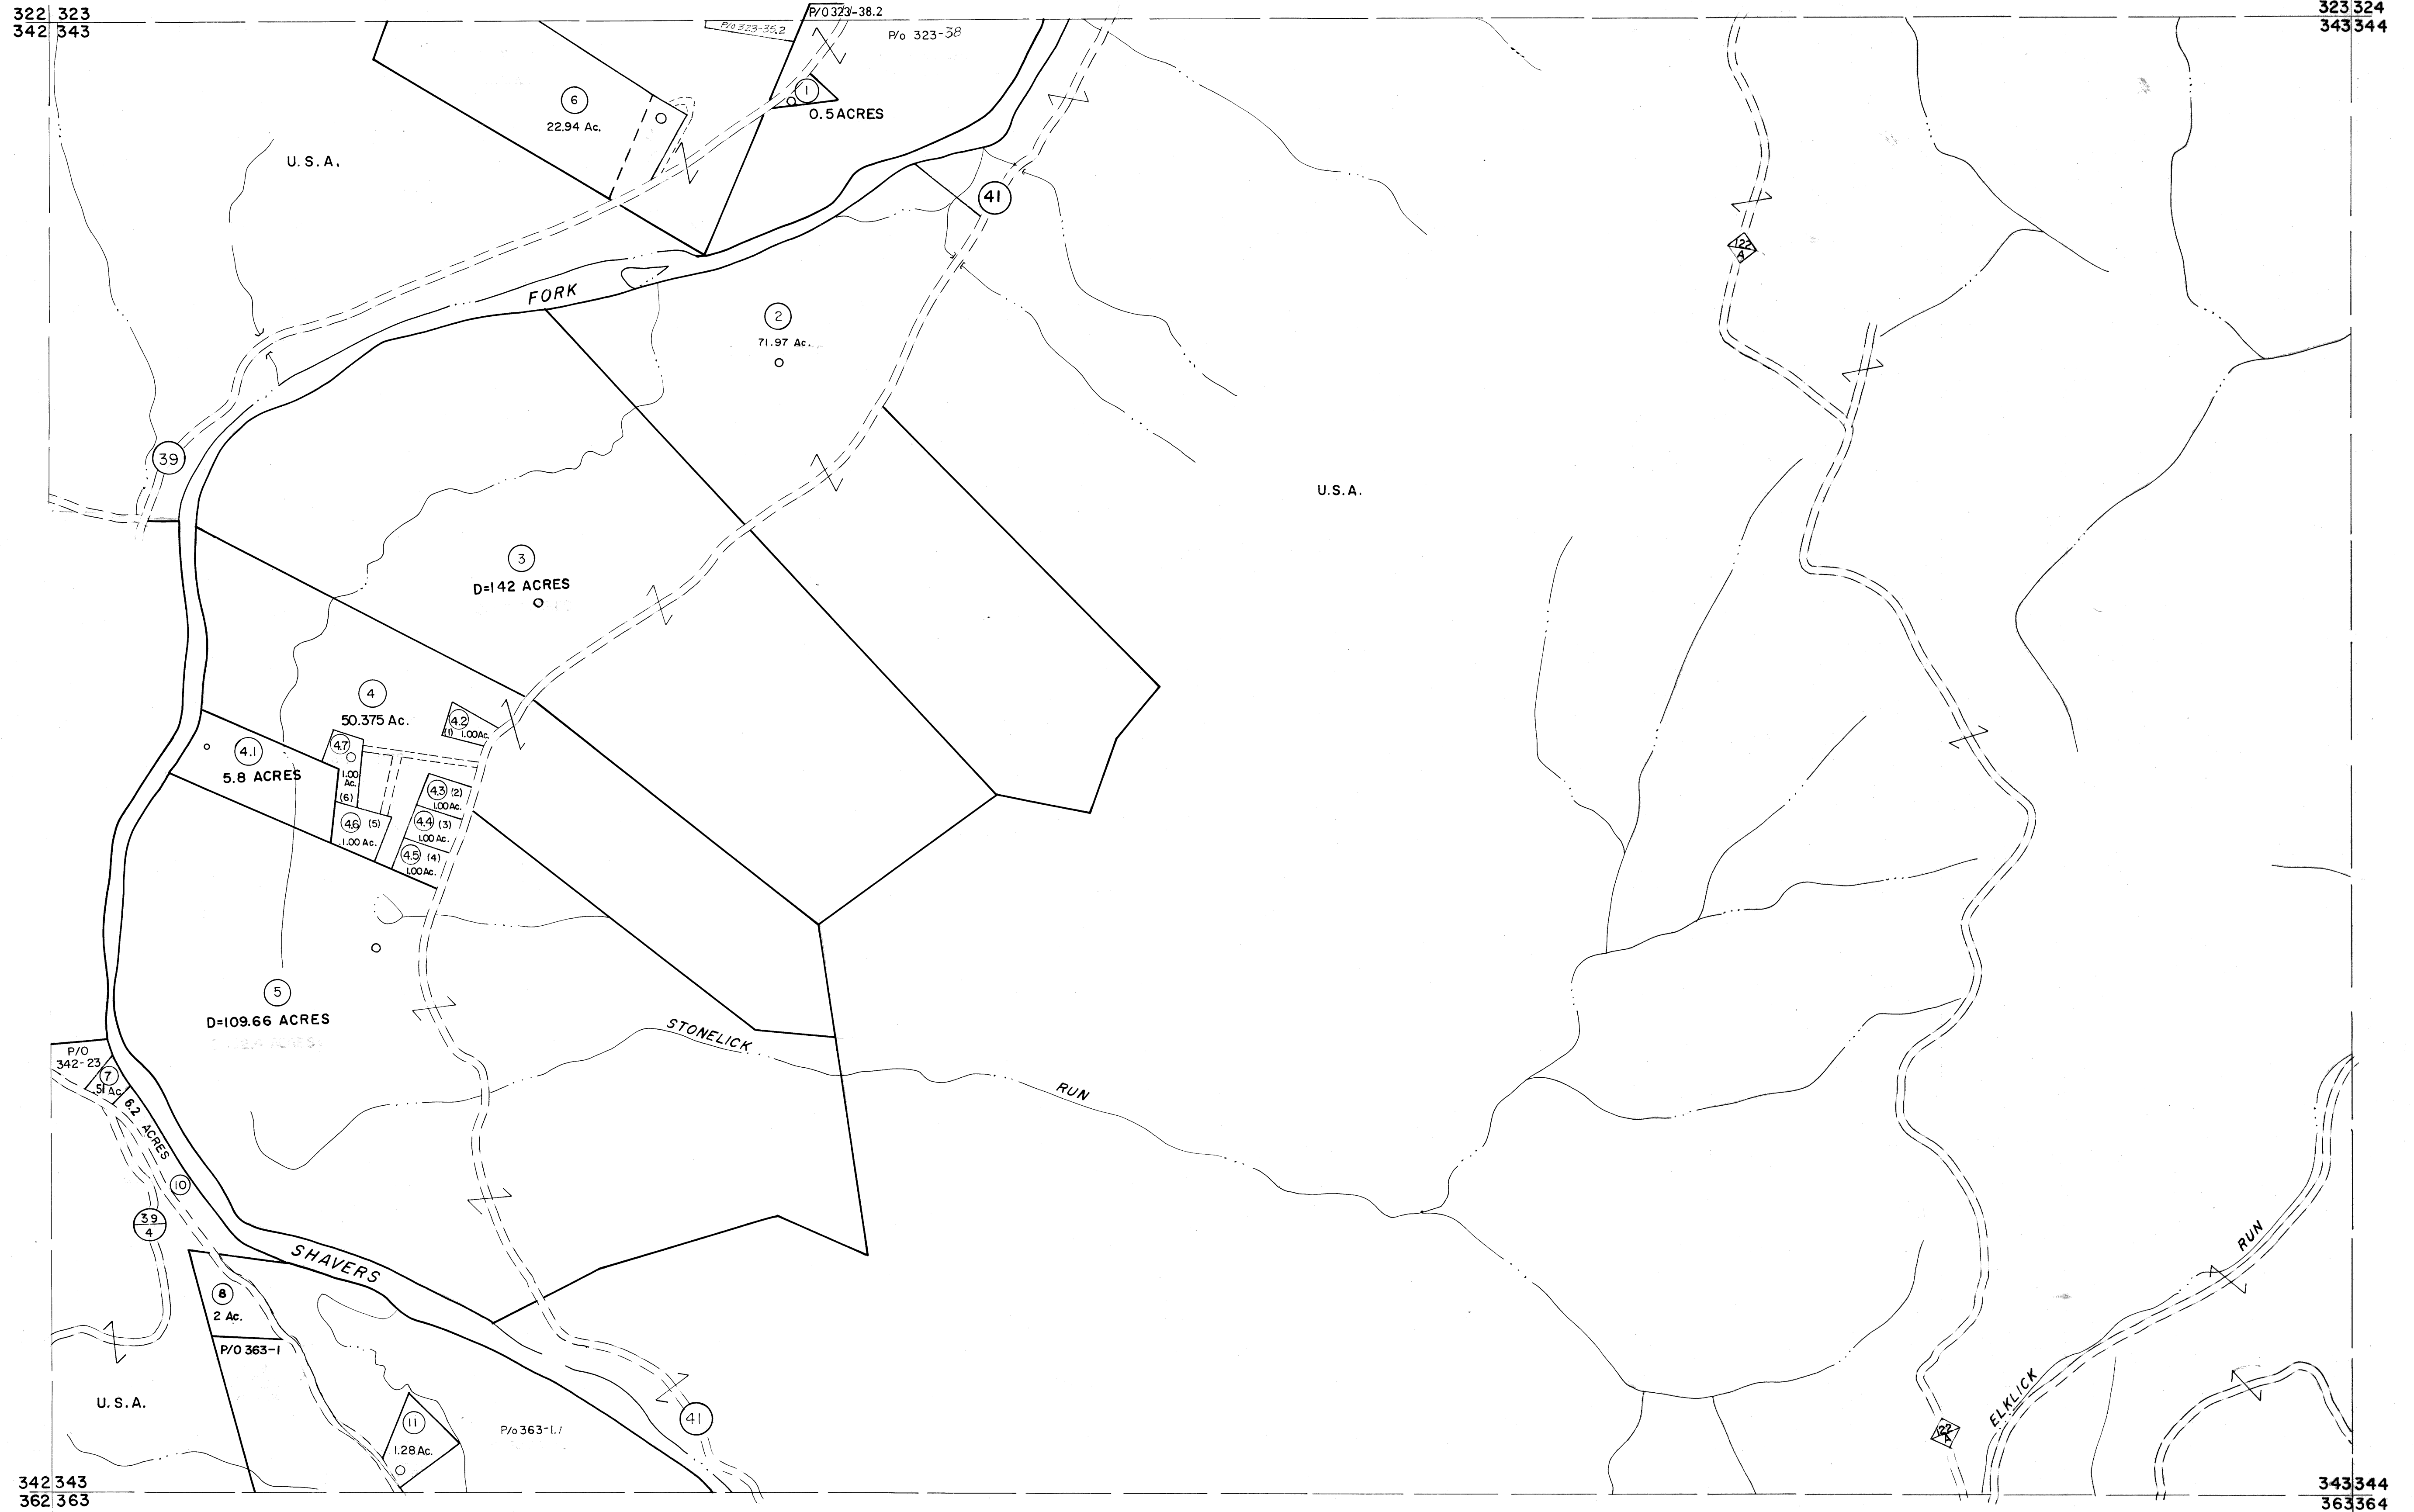

For Tax Purposes Only

Prepared by
MICHAEL BAKER, JR., INC.
Consulting Engineers
Rochester, Pennsylvania


Legend

Property line	—————	Original lot line	-----
Edge of pavement or roadway	-----	Deed lot number	(15)
Corporation line	-----	Parcel or index number	(39)
District line	-----	Improvement	o
County line	-----	Railroad	+

Revisions

No.	Description	Date	By
1	1/1-78 BAH	9	ESI
2	Revised to 7-1-83	10	ESI
3	July 1985	11	
4	Revised to 7-1-87	12	
5	OGIS 1/5/91 DSH	13	
6	OGIS 3-19-92 TL	14	
7	O.G.I.S. 4-1-96 J.E.B	15	
8	SLS INC. - DDC 5/97	16	

KEY MAP

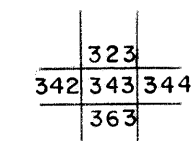

TUCKER COUNTY
STATE OF WEST VIRGINIA
Office of Assessor

DISTRICT

BLACKFORK

SHEET NO: 343

Date, Aerial Photography: November, 1961 Date, Map: Dec., 1962
Photo No: Scale: 1" = 400'